


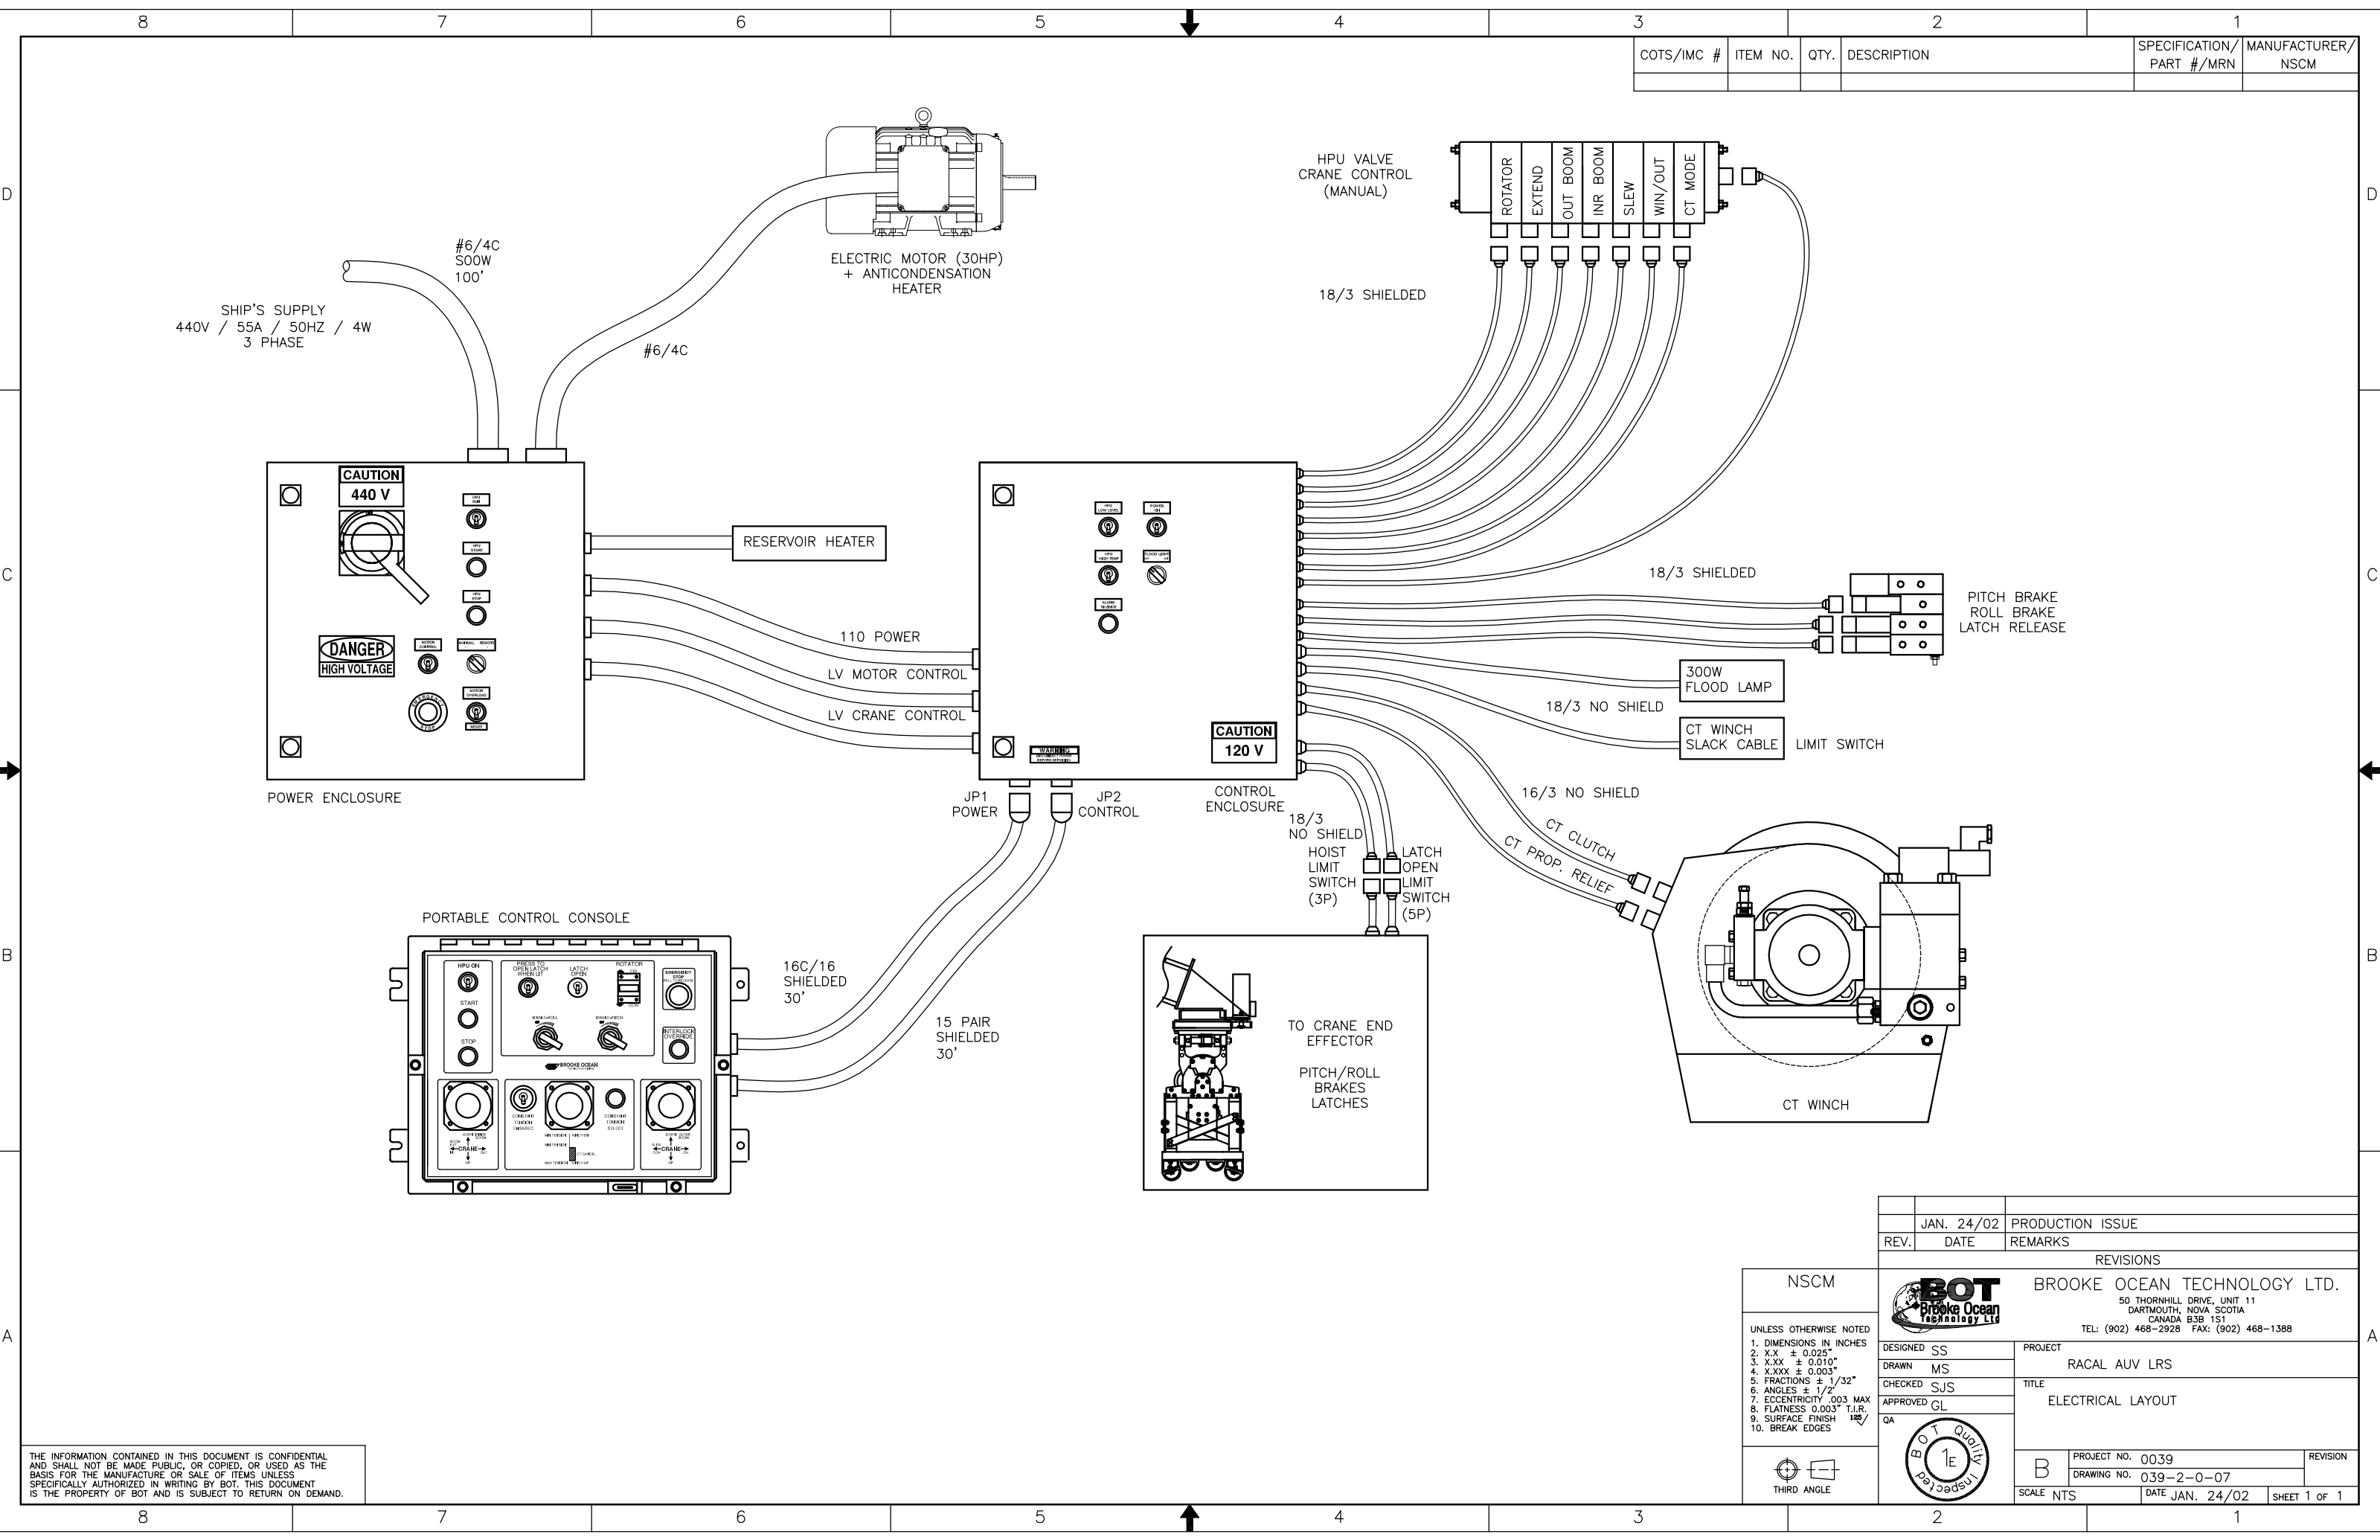

COTS/IMC #	ITEM NO.	QTY.	DESCRIPTION	SPECIFICATION/ PART #/MRN	MANUFACTURER/ NSCM

	JAN. 24/02	PRODUCTION ISSUE
REV.	DATE	REMARKS
REVISIONS		
BROOKE OCEAN TECHNOLOGY LTD.		
50 THORNHILL DRIVE, UNIT 11 DARTMOUTH, NOVA SCOTIA CANADA B3B 1S1 TEL: (902) 468-2928 FAX: (902) 468-1388		
DESIGNED SS	PROJECT	
DRAWN MS	RACAL AUV LRS	
CHECKED SJS	TITLE	
APPROVED GL	ELECTRICAL LAYOUT	
QA		
PROJECT NO. 0039		REVISION
DRAWING NO. 039-2-0-07		
SCALE NTS	DATE JAN. 24/02	SHEET 1 OF 1

NSCM
UNLESS OTHERWISE NOTED 1. DIMENSIONS IN INCHES 2. X.X ± 0.025" 3. X.XX ± 0.010" 4. X.XXX ± 0.003" 5. FRACTIONS ± 1/32" 6. ANGLES ± 1/2° 7. ECCENTRICITY .003 MAX 8. FLATNESS 0.003" T.I.R. 9. SURFACE FINISH 125/ 10. BREAK EDGES
THIRD ANGLE

THE INFORMATION CONTAINED IN THIS DOCUMENT IS CONFIDENTIAL AND SHALL NOT BE MADE PUBLIC, OR COPIED, OR USED AS THE BASIS FOR THE MANUFACTURE OR SALE OF ITEMS UNLESS SPECIFICALLY AUTHORIZED IN WRITING BY BOT. THIS DOCUMENT IS THE PROPERTY OF BOT AND IS SUBJECT TO RETURN ON DEMAND.