




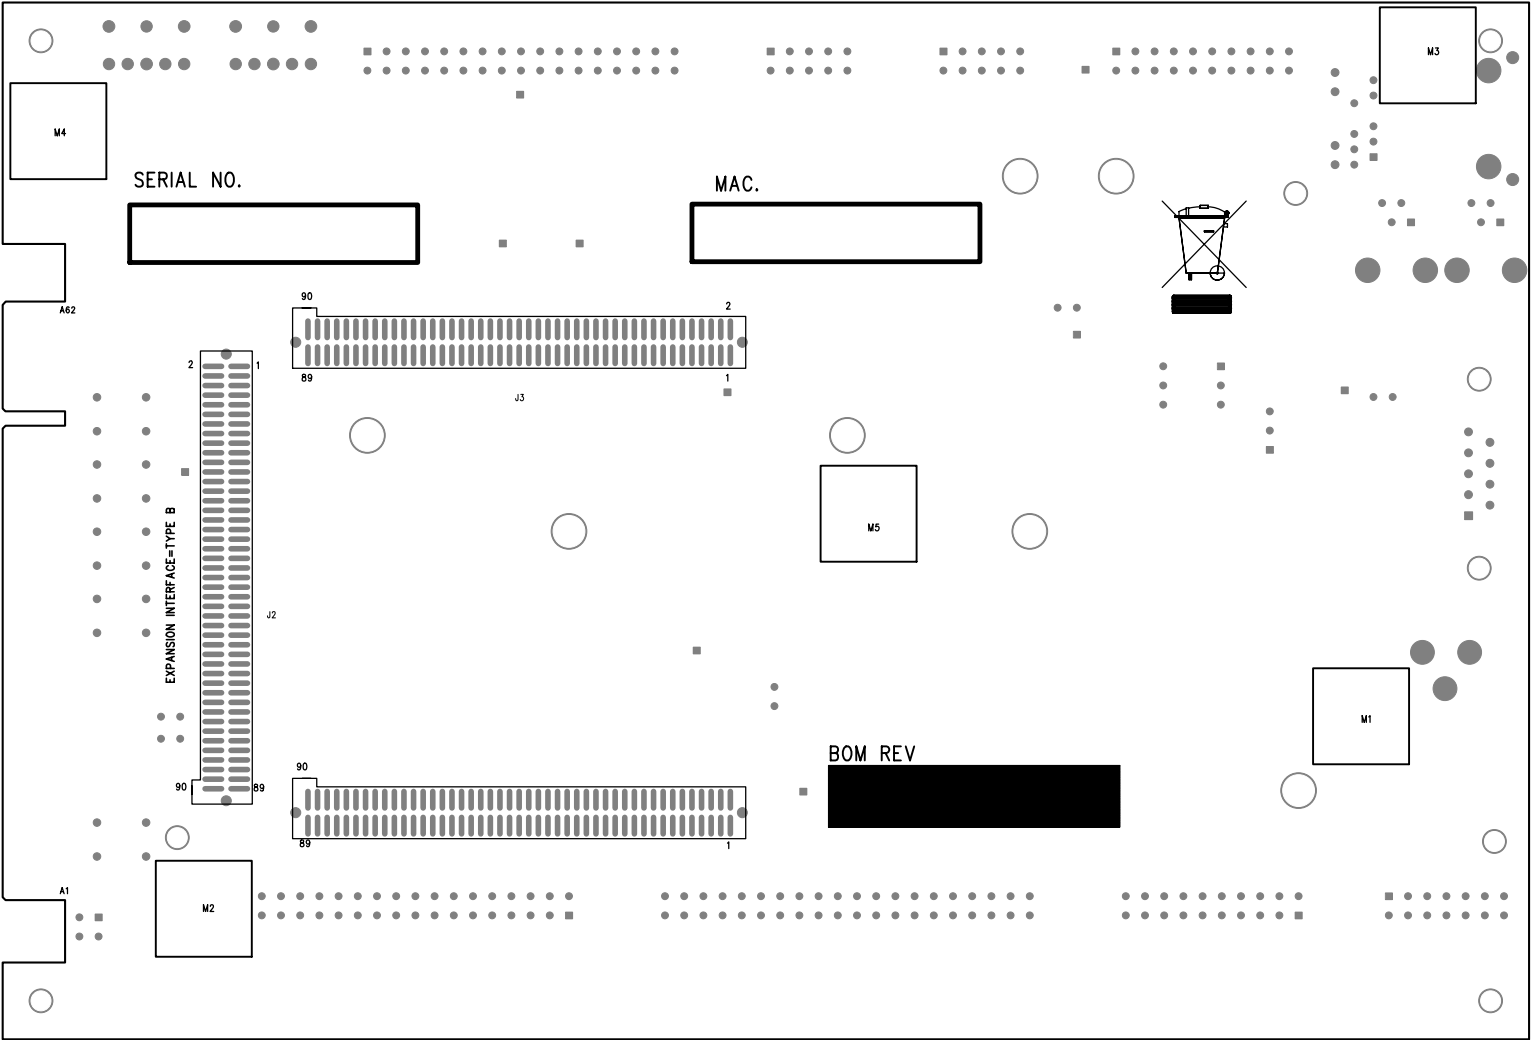

UNLESS OTHERWISE SPECIFIED DIMENSIONS ARE IN INCHES TOLERANCES ARE : .XX +/- .010 .XXX +/- .005	CONTRACT NO.		 20 Cotton Road Nashua, New Hampshire 03063 (603) 883-2430 FAX (603) 882-2655		
	APPROVALS	DATE			
MATERIAL	DRAWN	01/23/07	ASSEMBLY DRAWING BOTTOM SIDE ADSP-BF537 EZ-KIT LITE		
	CHECKED				
FINISH	ENGINEERING		SIZE B	DWG. NO. ASSMAA0188-2004-REF	REV. 2.2
	QUALITY				
DO NOT SCALE THIS DRAWING	MANUFACTURING		SCALE 1 : 1		SHEET 2 OF 2

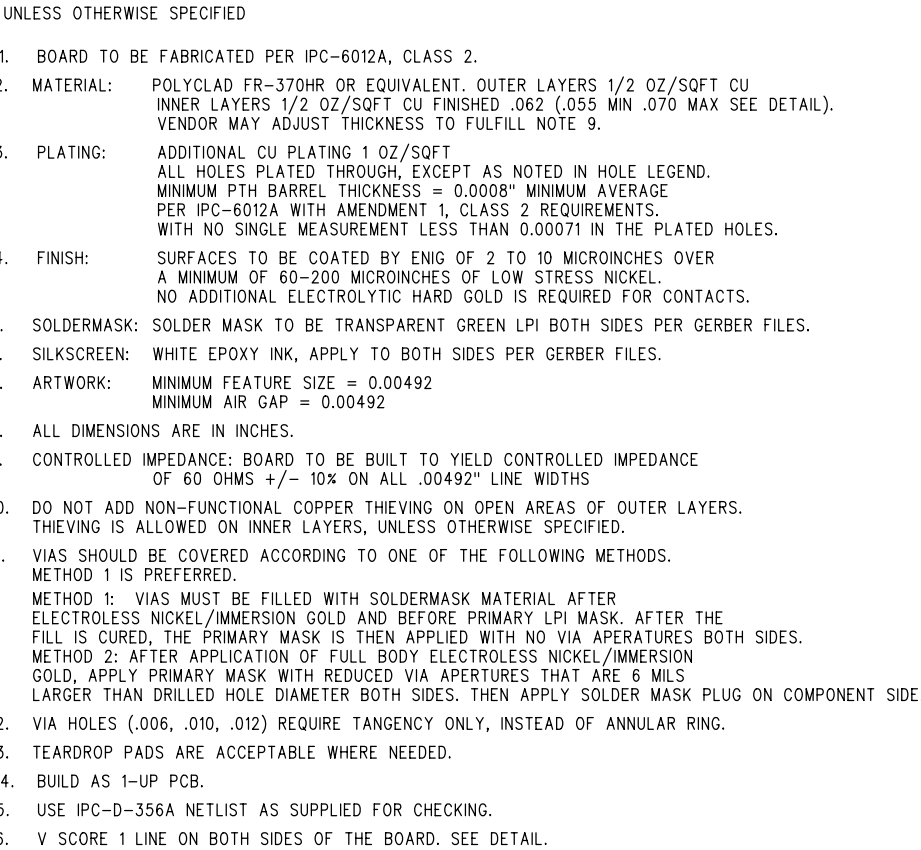


UNLESS OTHERWISE SPECIFIED DIMENSIONS ARE IN INCHES TOLERANCES ARE : .XX +/- .010 .XXX +/- .005		CONTRACT NO.		 ANALOG DEVICES 20 Cotton Road Nashua, New Hampshire 03063 (603) 883-2430 FAX (603) 882-2655		
		APPROVALS	DATE			
MATERIAL SEE NOTES	DRAWN	01/23/07	FABRICATION DRAWING ADSP-BF537 EZ-KIT LITE			
	CHECKED					
FINISH SEE NOTES	ENGINEERING		SIZE B	DWG. NO.	A0188-2004-REF	REV. 2.2
	QUALITY					
DO NOT SCALE THIS DRAWING	MANUFACTURING		SCALE	1 : 1	SHEET	1 OF 1

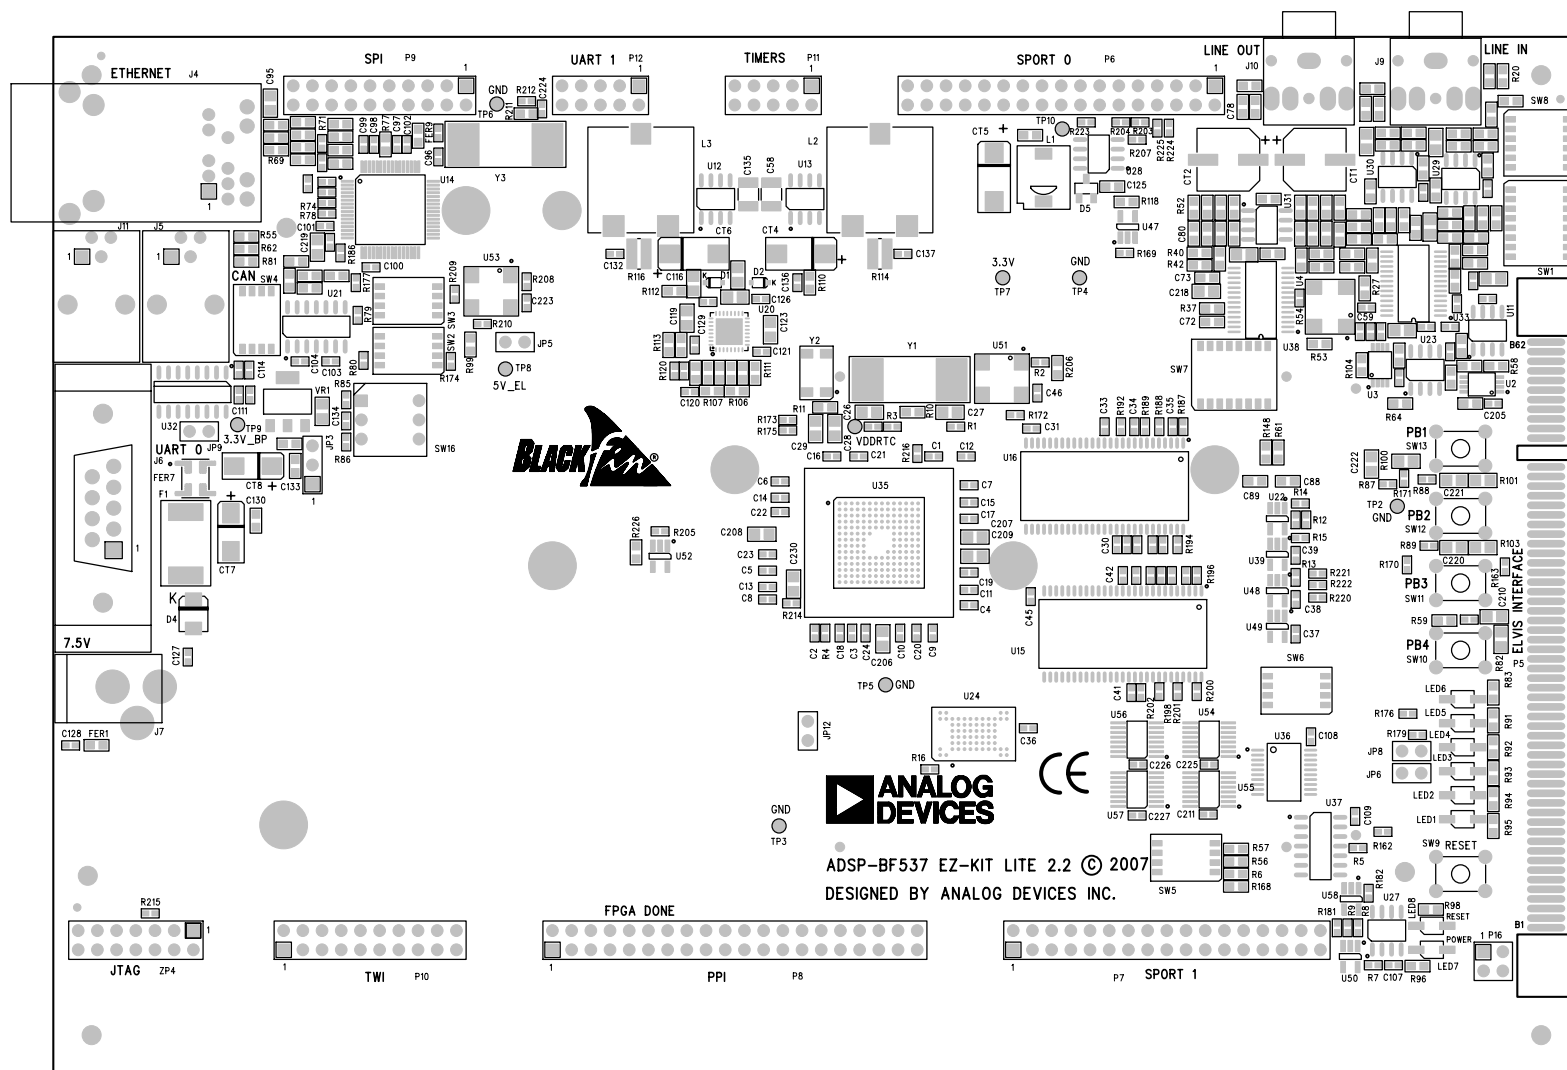


ADSP-BF537 EZ-KIT LITE 2.2 © 2007
DESIGNED BY ANALOG DEVICES INC.


UNLESS OTHERWISE SPECIFIED DIMENSIONS ARE IN INCHES TOLERANCES ARE : .XX +/- .010 .XXX +/- .005	CONTRACT NO.		 20 Cotton Road Nashua, New Hampshire 03063 (603) 883-2430 FAX (603) 882-2655
	APPROVALS	DATE	
MATERIAL	DRAWN	01/23/07	SILKSCREEN TOP SIDE ADSP-BF537 EZ-KIT LITE
FINISH	CHECKED		
DO NOT SCALE THIS DRAWING	ENGINEERING		SCALE 1 : 1
	QUALITY		
	MANUFACTURING		DWG. NO. A0188-2004-REF
			REV. 2.2
			SHEET 11 OF 14

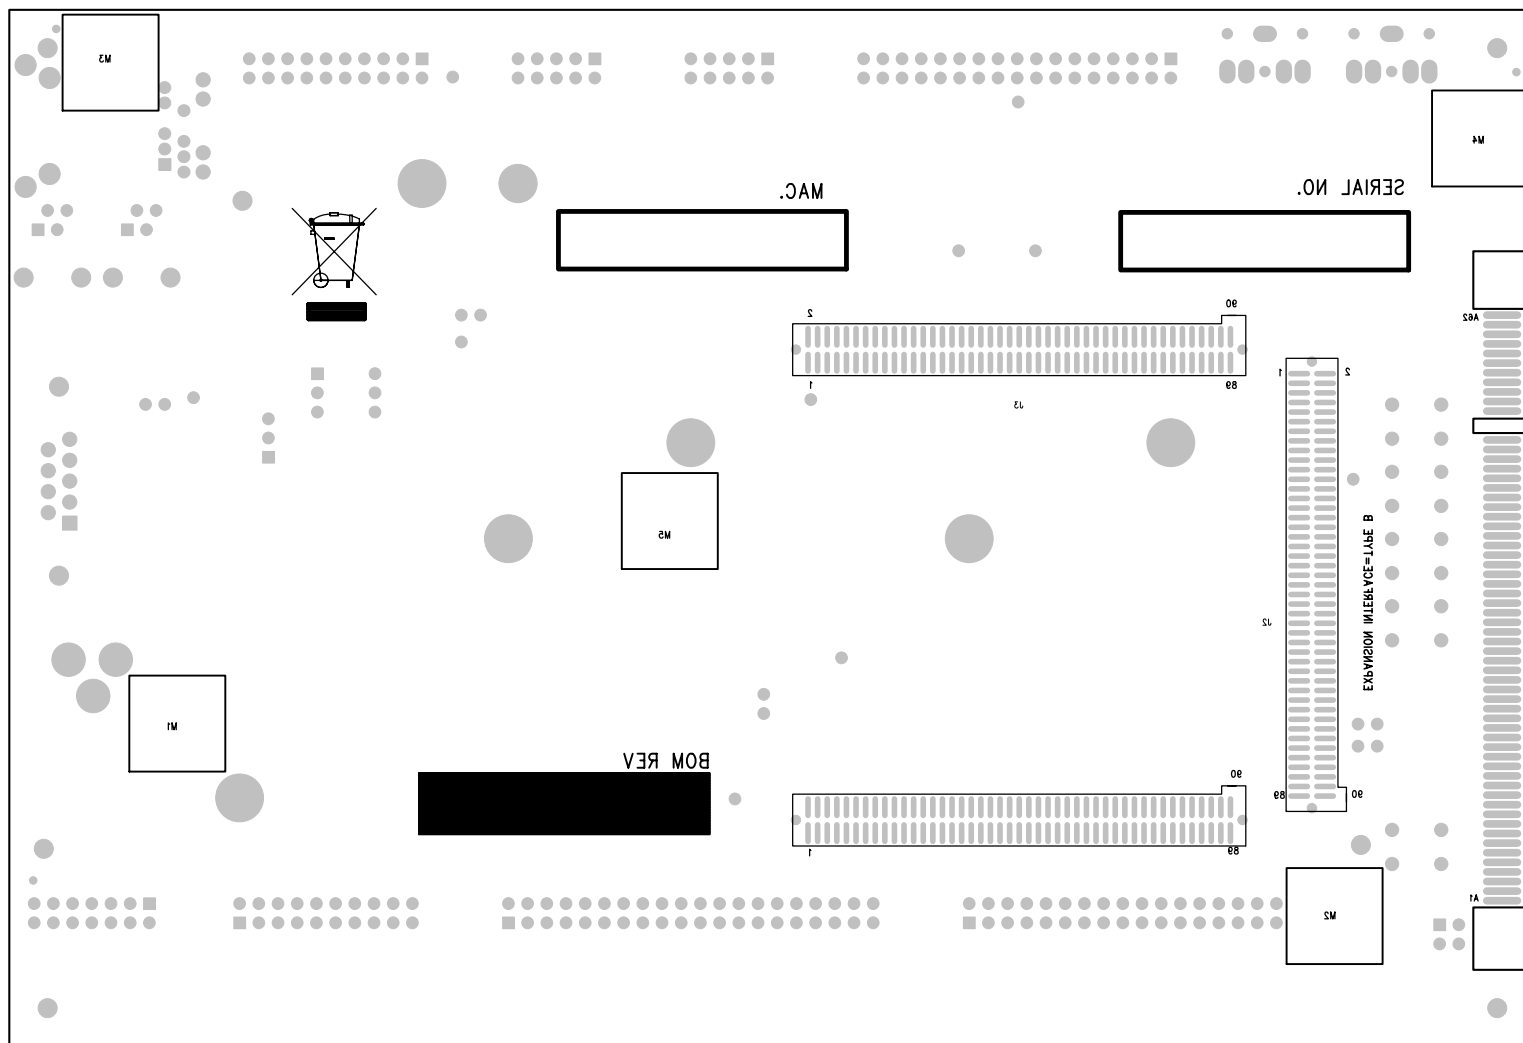


UNLESS OTHERWISE SPECIFIED DIMENSIONS ARE IN INCHES TOLERANCES ARE : .XX +/- .010 .XXX +/- .005	CONTRACT NO.		 20 Cotton Road Nashua, New Hampshire 03063 (603) 883-2430 FAX (603) 882-2655	
	APPROVALS	DATE		
MATERIAL	DRAWN	01/23/07	SILKSCREEN BOTTOM SIDE ADSP-BF537 EZ-KIT LITE	
	CHECKED			
FINISH	ENGINEERING		SIZE	DWG. NO. A0188-2004-REF
	QUALITY		B	
DO NOT SCALE THIS DRAWING	MANUFACTURING		SCALE 1 : 1	REV. 2.2
			SHEET 12 OF 14	

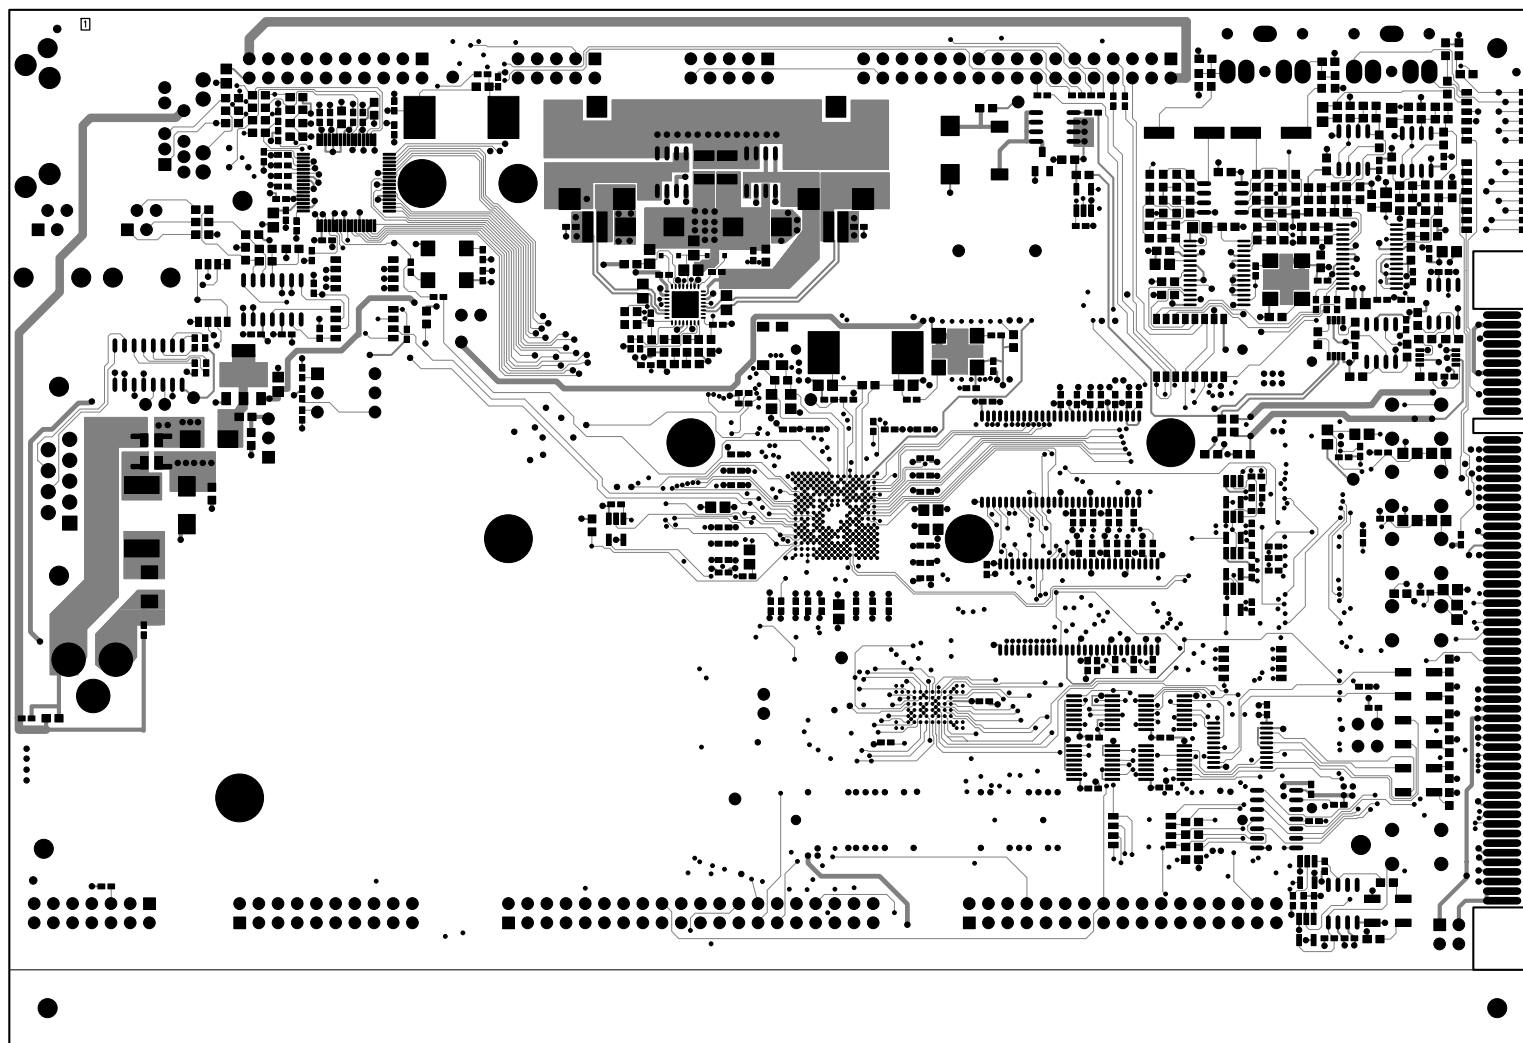


UNLESS OTHERWISE SPECIFIED DIMENSIONS ARE IN INCHES TOLERANCES ARE : .XX +/- .010 .XXX +/- .005	CONTRACT NO.		 20 Cotton Road Nashua, New Hampshire 03063 (603) 883-2430 FAX (603) 882-2655		
	APPROVALS	DATE			
MATERIAL	DRAWN	01/23/07	LAYER 1 TOP SIDE ADSP-BF537 EZ-KIT LITE		
	CHECKED				
FINISH	ENGINEERING		SIZE	DWG. NO. A0188-2004-REF	REV. 2.2
	QUALITY		B		
DO NOT SCALE THIS DRAWING	MANUFACTURING		SCALE 1 : 1	SHEET 1 OF 14	

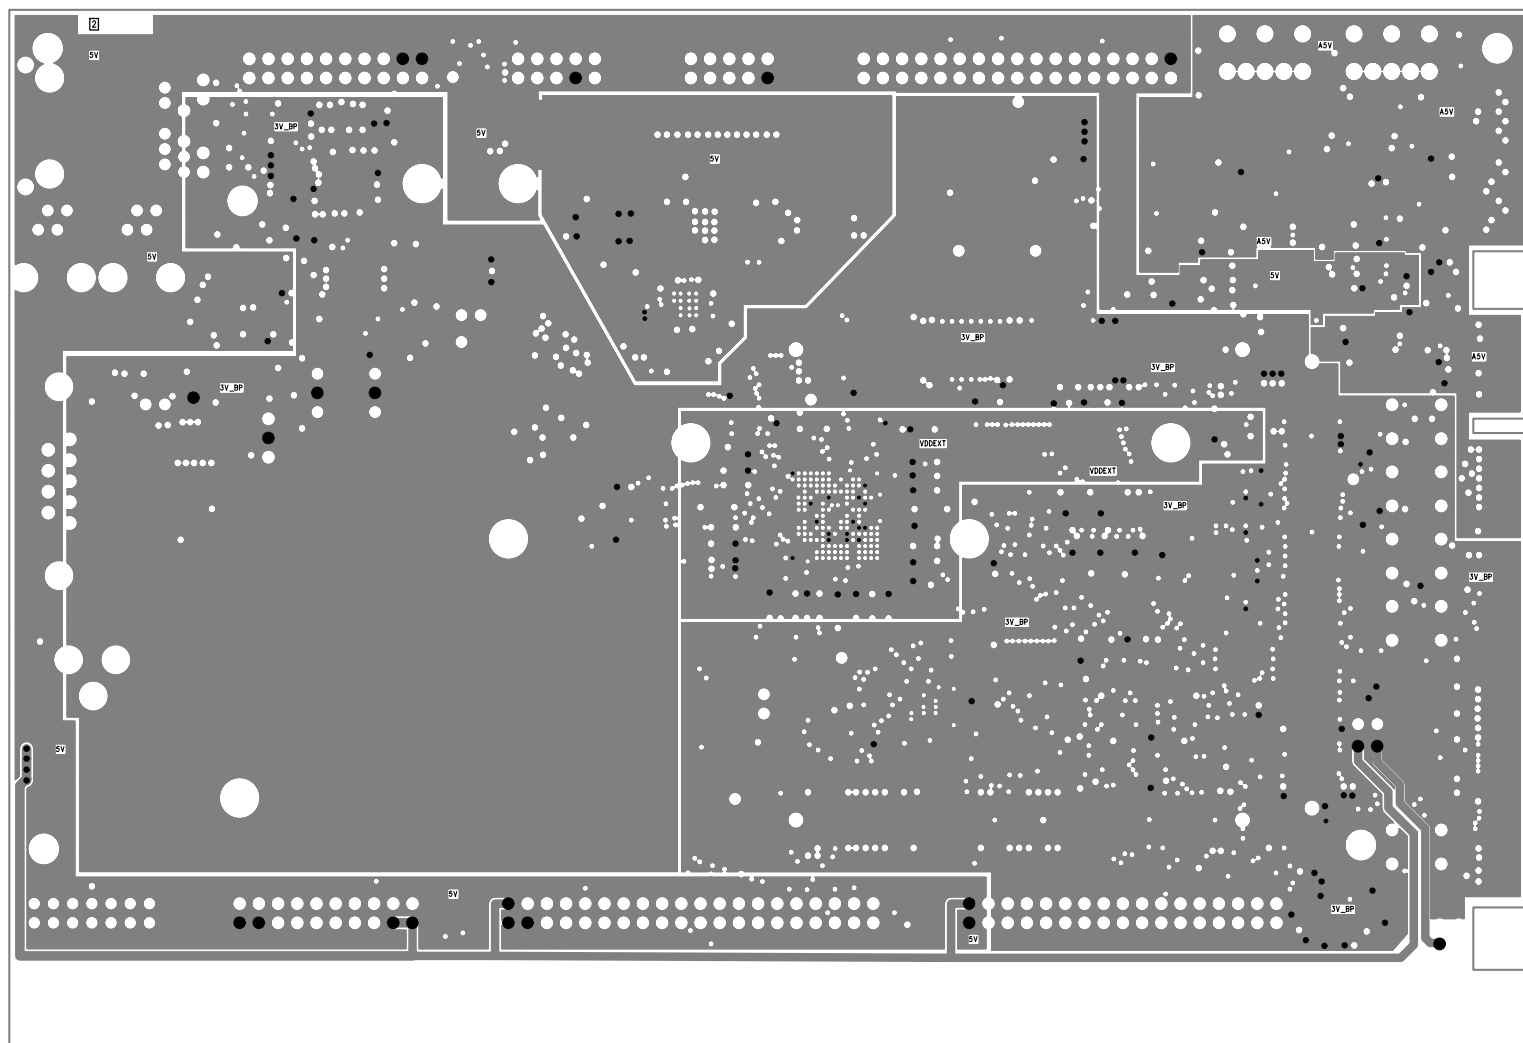


UNLESS OTHERWISE SPECIFIED DIMENSIONS ARE IN INCHES TOLERANCES ARE : .XX +/- .010 .XXX +/- .005	CONTRACT NO.		 20 Cotton Road Nashua, New Hampshire 03063 (603) 883-2430 FAX (603) 882-2655	
	APPROVALS	DATE		
MATERIAL	DRAWN	01/23/07	LAYER 2 POWER PLANE 1 ADSP-BF537 EZ-KIT LITE	
	CHECKED			
FINISH	ENGINEERING		SIZE	REV.
	QUALITY		B	2.2
DO NOT SCALE THIS DRAWING	MANUFACTURING		DWG. NO.	
			A0188-2004-REF	
			SCALE 1 : 1	SHEET 2 OF 14

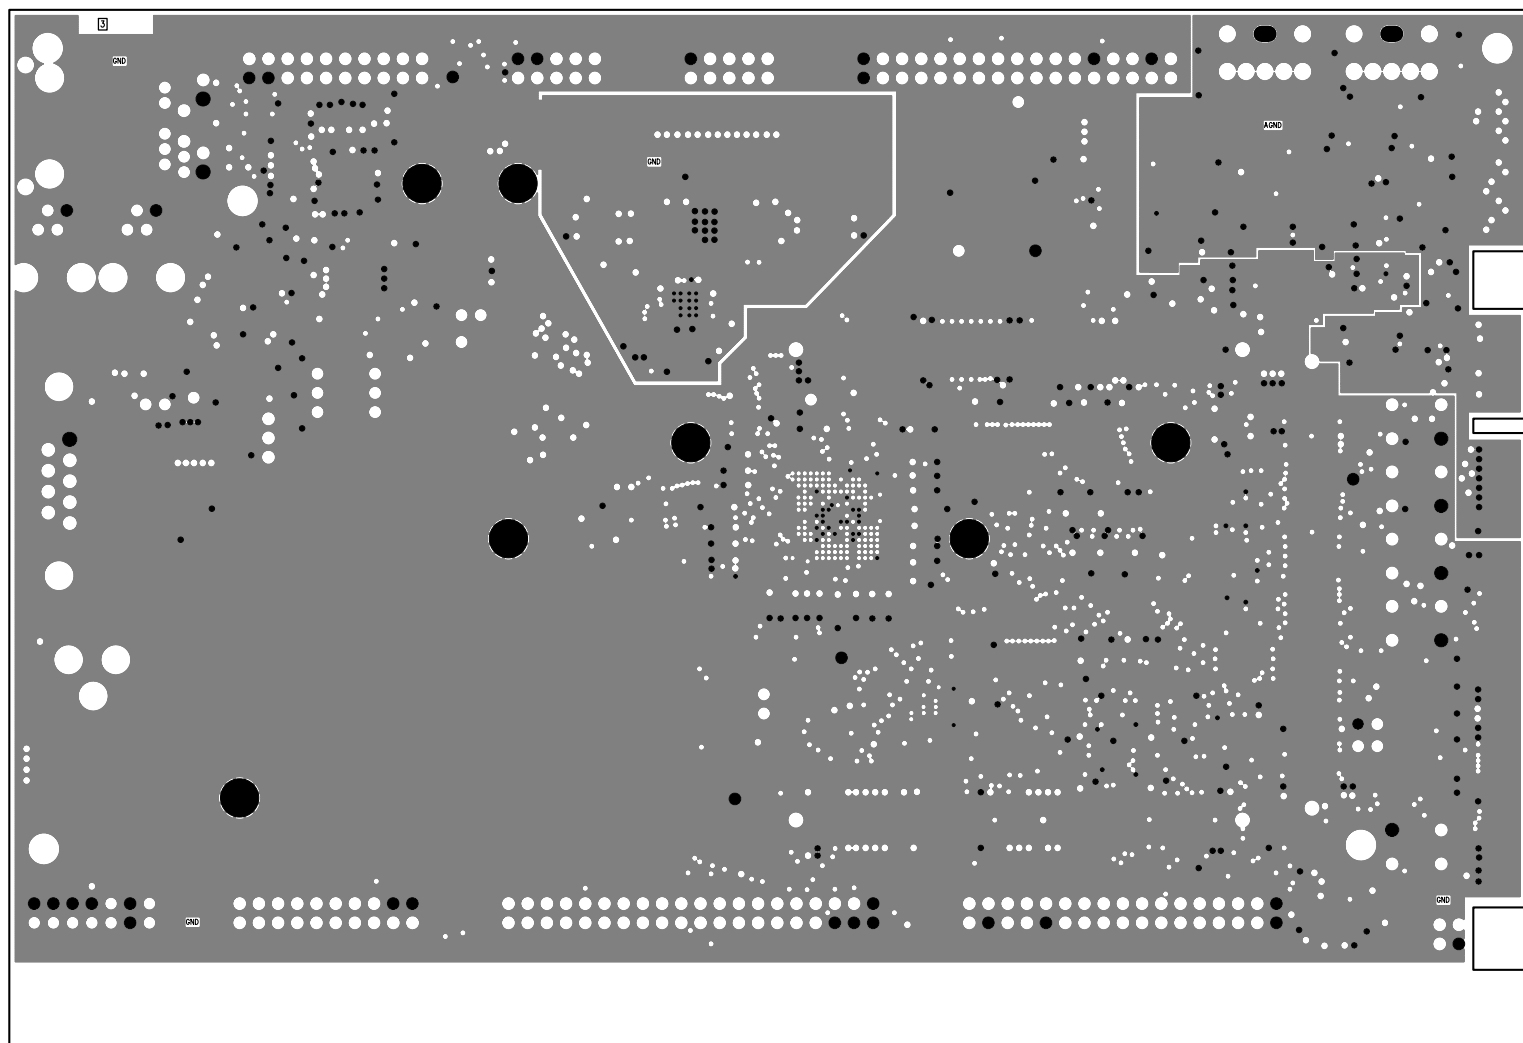


UNLESS OTHERWISE SPECIFIED DIMENSIONS ARE IN INCHES TOLERANCES ARE : .XX +/- .010 .XXX +/- .005	CONTRACT NO.		 20 Cotton Road Nashua, New Hampshire 03063 (603) 883-2430 FAX (603) 882-2655	
	APPROVALS	DATE		
MATERIAL	DRAWN	01/23/07	LAYER 3 GROUND PLANE ADSP-BF537 EZ-KIT LITE	
	CHECKED			
FINISH	ENGINEERING		SIZE	DWG. NO. A0188-2004-REF
	QUALITY		B	
DO NOT SCALE THIS DRAWING	MANUFACTURING		SCALE 1 : 1	REV. 2.2 SHEET 3 OF 14

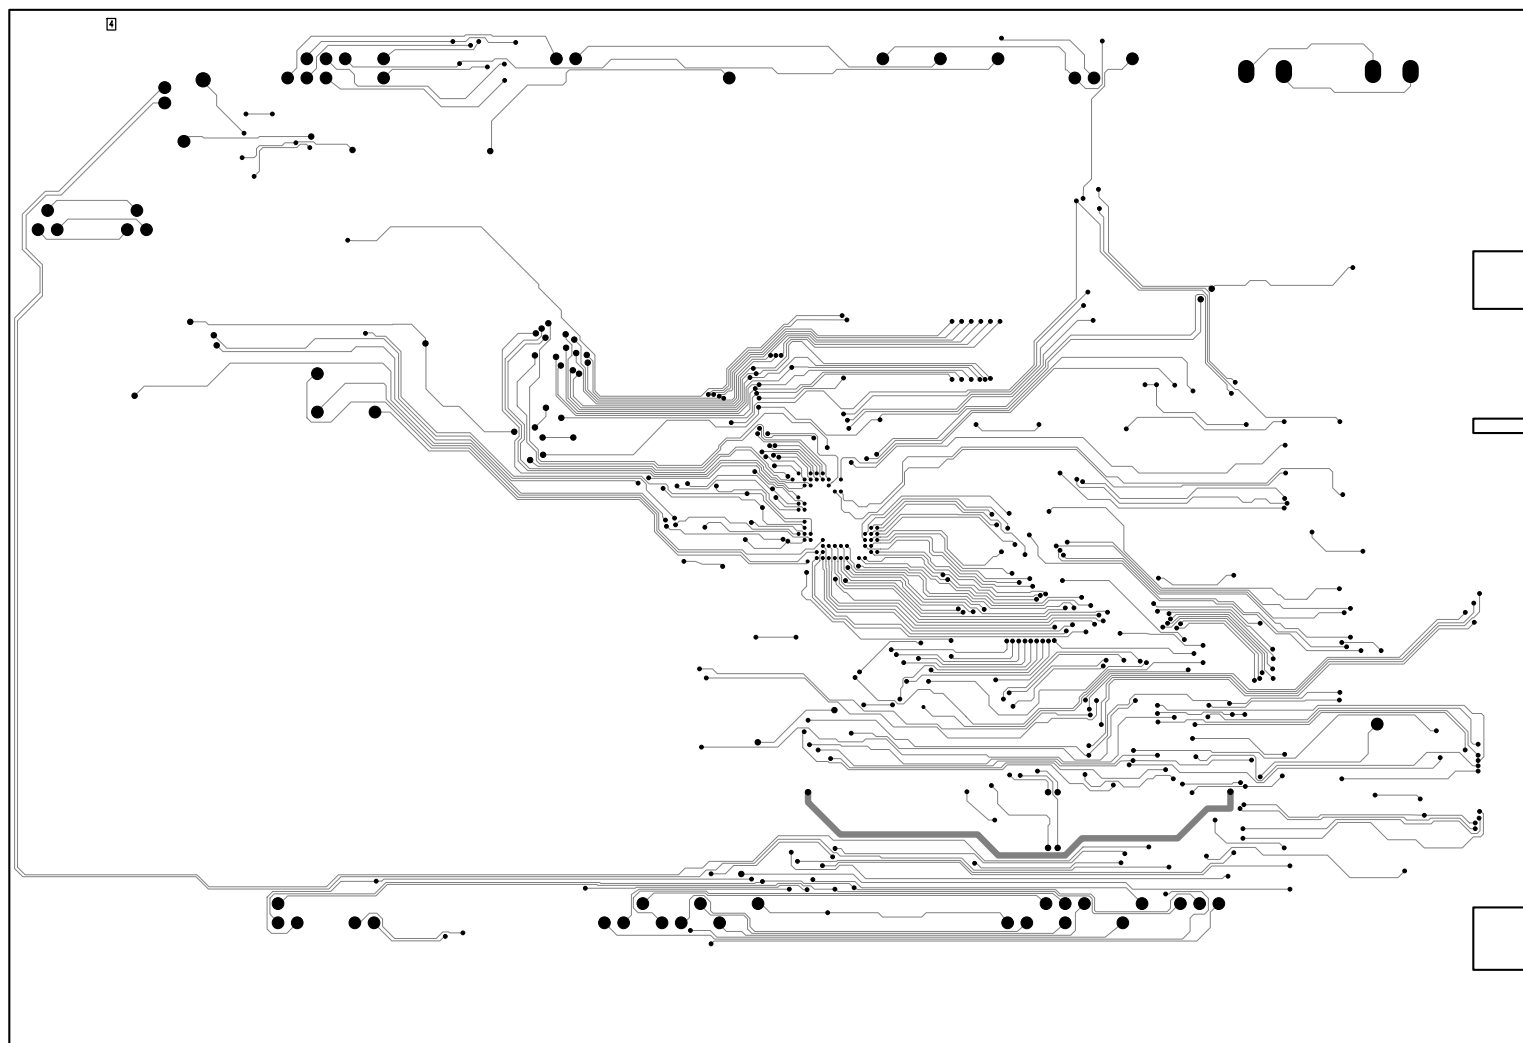


UNLESS OTHERWISE SPECIFIED DIMENSIONS ARE IN INCHES TOLERANCES ARE : .XX +/- .010 .XXX +/- .005	CONTRACT NO.		 20 Cotton Road Nashua, New Hampshire 03063 (603) 883-2430 FAX (603) 882-2655	
	APPROVALS	DATE		
MATERIAL	DRAWN	01/23/07	LAYER 4 INTERNAL SIGNAL ADSP-BF537 EZ-KIT LITE	
	CHECKED			
FINISH	ENGINEERING		SIZE B	DWG. NO. A0188-2004-REF
	QUALITY			
DO NOT SCALE THIS DRAWING	MANUFACTURING		SCALE 1 : 1	REV. 2.2
			SHEET 4 OF 14	

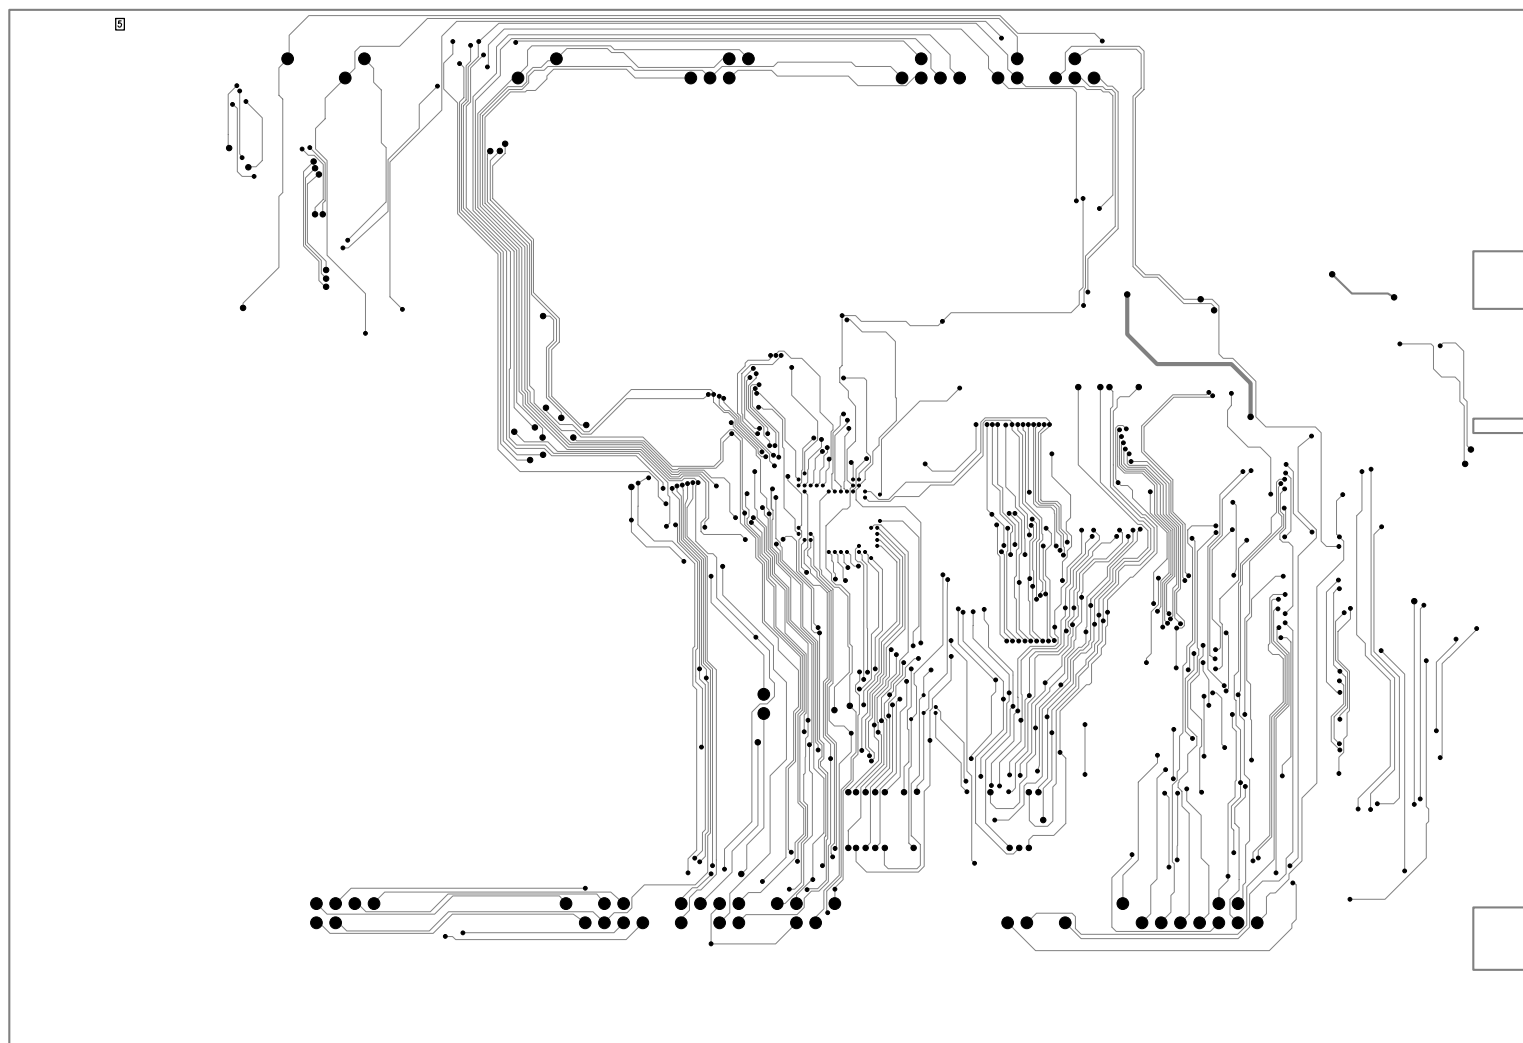


UNLESS OTHERWISE SPECIFIED DIMENSIONS ARE IN INCHES TOLERANCES ARE : .XX +/- .010 .XXX +/- .005	CONTRACT NO.		 20 Cotton Road Nashua, New Hampshire 03063 (603) 883-2430 FAX (603) 882-2655	
	APPROVALS	DATE		
MATERIAL	DRAWN	01/23/07	LAYER 5 INTERNAL SIGNAL ADSP-BF537 EZ-KIT LITE	
	CHECKED			
FINISH	ENGINEERING		SIZE	REV.
	QUALITY		B	2.2
DO NOT SCALE THIS DRAWING	MANUFACTURING		SCALE 1 : 1	SHEET 5 OF 14
			DWG. NO.	A0188-2004-REF

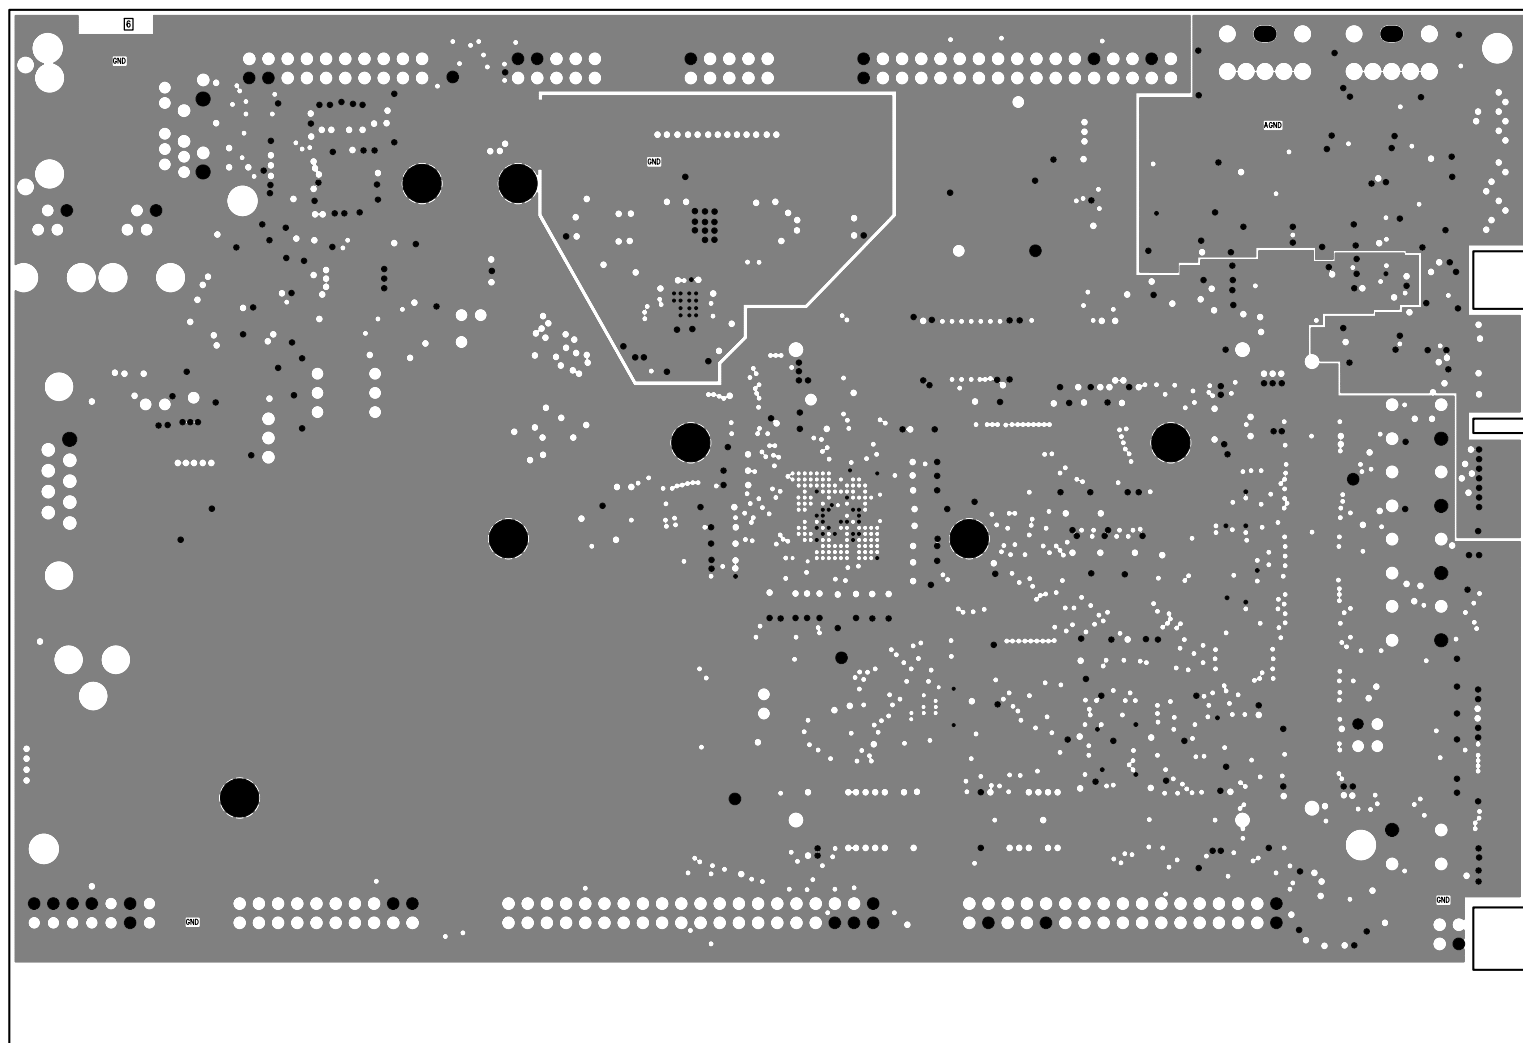


UNLESS OTHERWISE SPECIFIED DIMENSIONS ARE IN INCHES TOLERANCES ARE : .XX +/- .010 .XXX +/- .005	CONTRACT NO.		 20 Cotton Road Nashua, New Hampshire 03063 (603) 883-2430 FAX (603) 882-2655	
	APPROVALS	DATE		
MATERIAL	DRAWN	01/23/07	LAYER 6 GROUND PLANE ADSP-BF537 EZ-KIT LITE	
	CHECKED			
FINISH	ENGINEERING		SIZE	DWG. NO. A0188-2004-REF
	QUALITY		B	
DO NOT SCALE THIS DRAWING	MANUFACTURING		SCALE 1 : 1	REV. 2.2 SHEET 6 OF 14

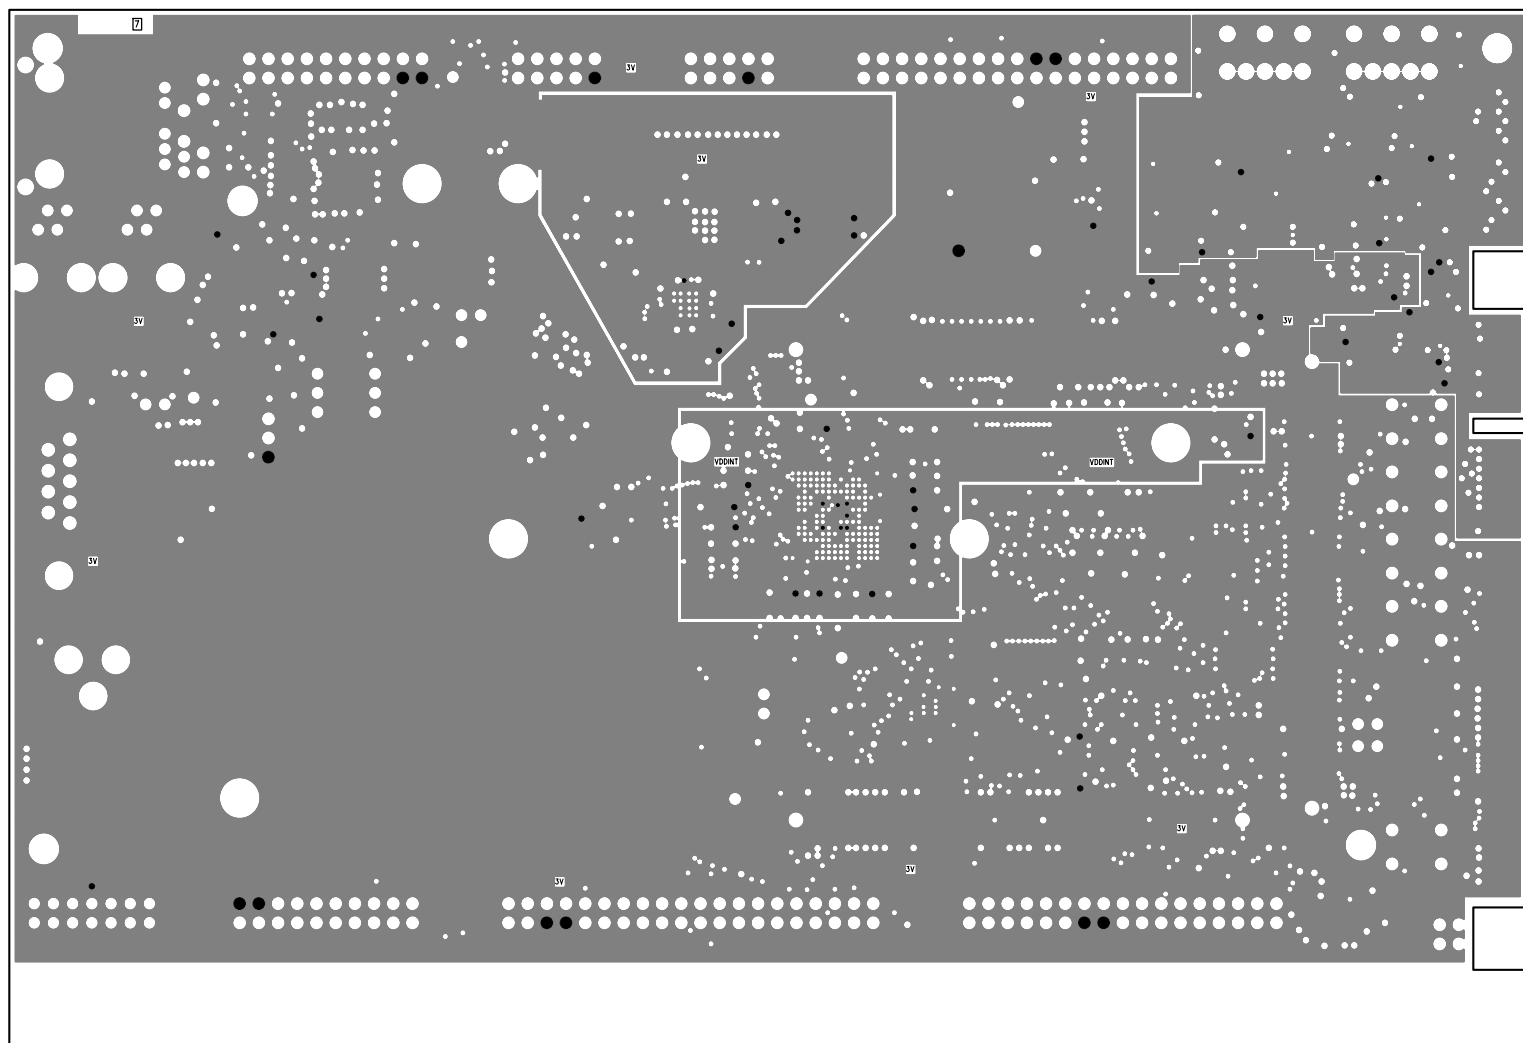


UNLESS OTHERWISE SPECIFIED DIMENSIONS ARE IN INCHES TOLERANCES ARE : .XX +/- .010 .XXX +/- .005	CONTRACT NO.		 20 Cotton Road Nashua, New Hampshire 03063 (603) 883-2430 FAX (603) 882-2655	
	APPROVALS	DATE		
MATERIAL	DRAWN	01/23/07	LAYER 7 POWER PLANE 2 ADSP-BF537 EZ-KIT LITE	
	CHECKED			
FINISH	ENGINEERING		SIZE	DWG. NO. A0188-2004-REF
	QUALITY		B	
DO NOT SCALE THIS DRAWING	MANUFACTURING		SCALE 1 : 1	REV. 2.2 SHEET 7 OF 14

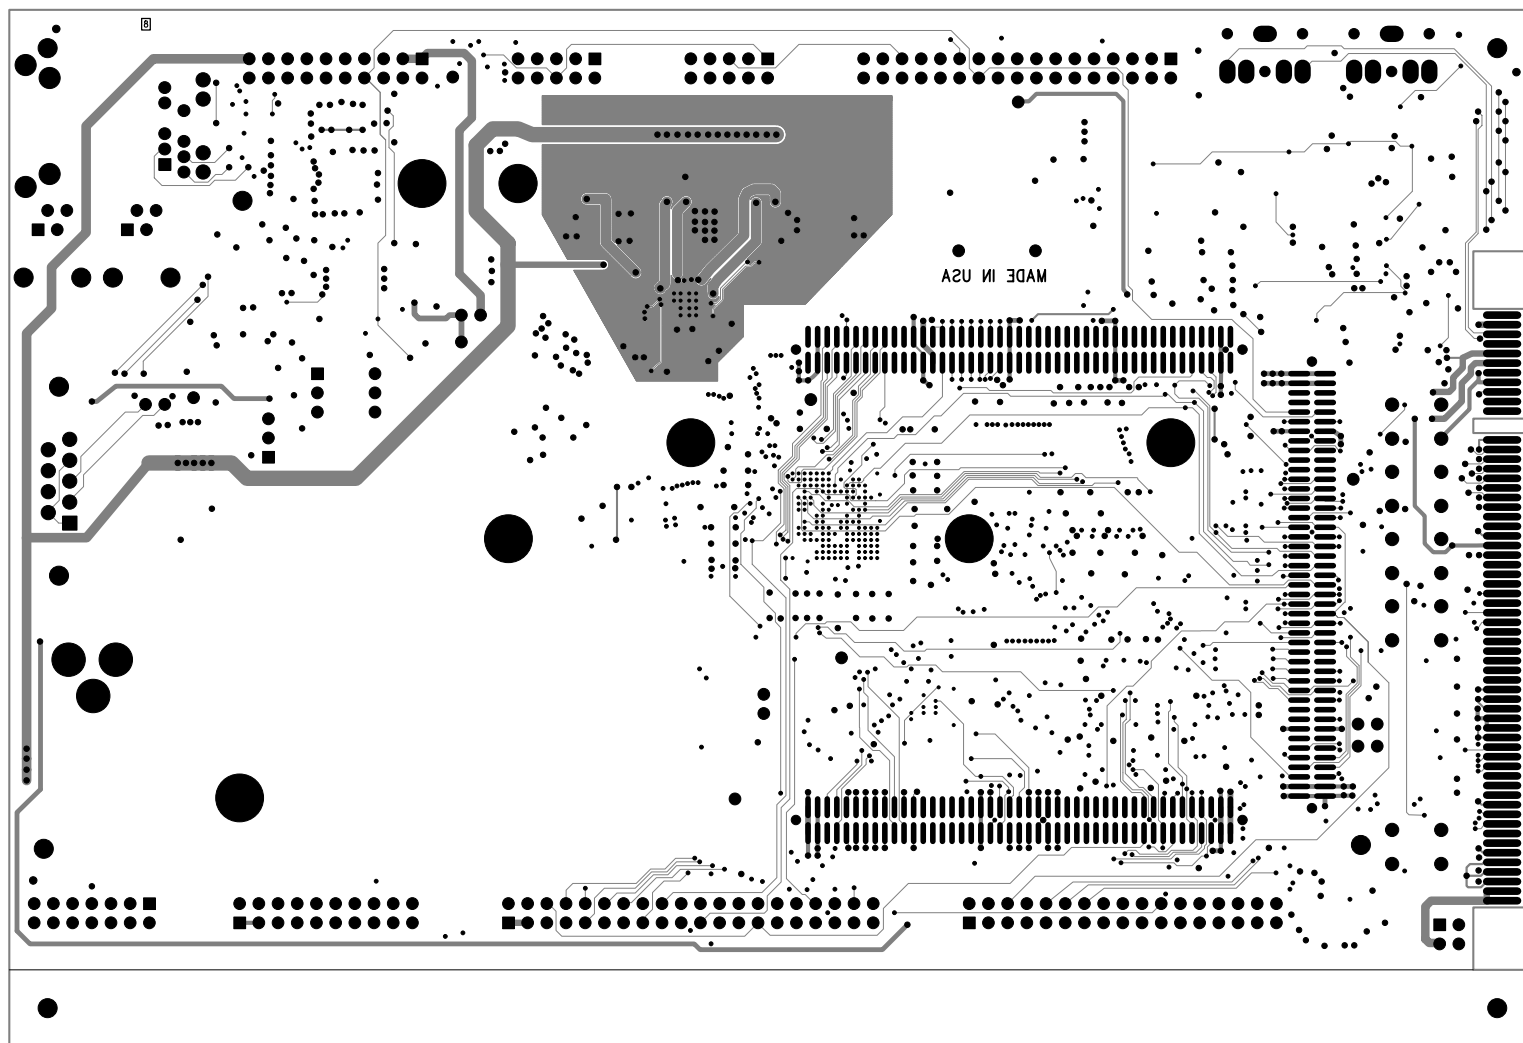


UNLESS OTHERWISE SPECIFIED DIMENSIONS ARE IN INCHES TOLERANCES ARE : .XX +/- .010 .XXX +/- .005	CONTRACT NO.		 20 Cotton Road Nashua, New Hampshire 03063 (603) 883-2430 FAX (603) 882-2655		
	APPROVALS	DATE			
MATERIAL	DRAWN	01/23/07	LAYER 8 BOTTOM SIDE ADSP-BF537 EZ-KIT LITE		
	CHECKED				
FINISH	ENGINEERING		SIZE	DWG. NO. A0188-2004-REF	REV. 2.2
	QUALITY		B		
DO NOT SCALE THIS DRAWING	MANUFACTURING		SCALE 1 : 1	SHEET 8 OF 14	

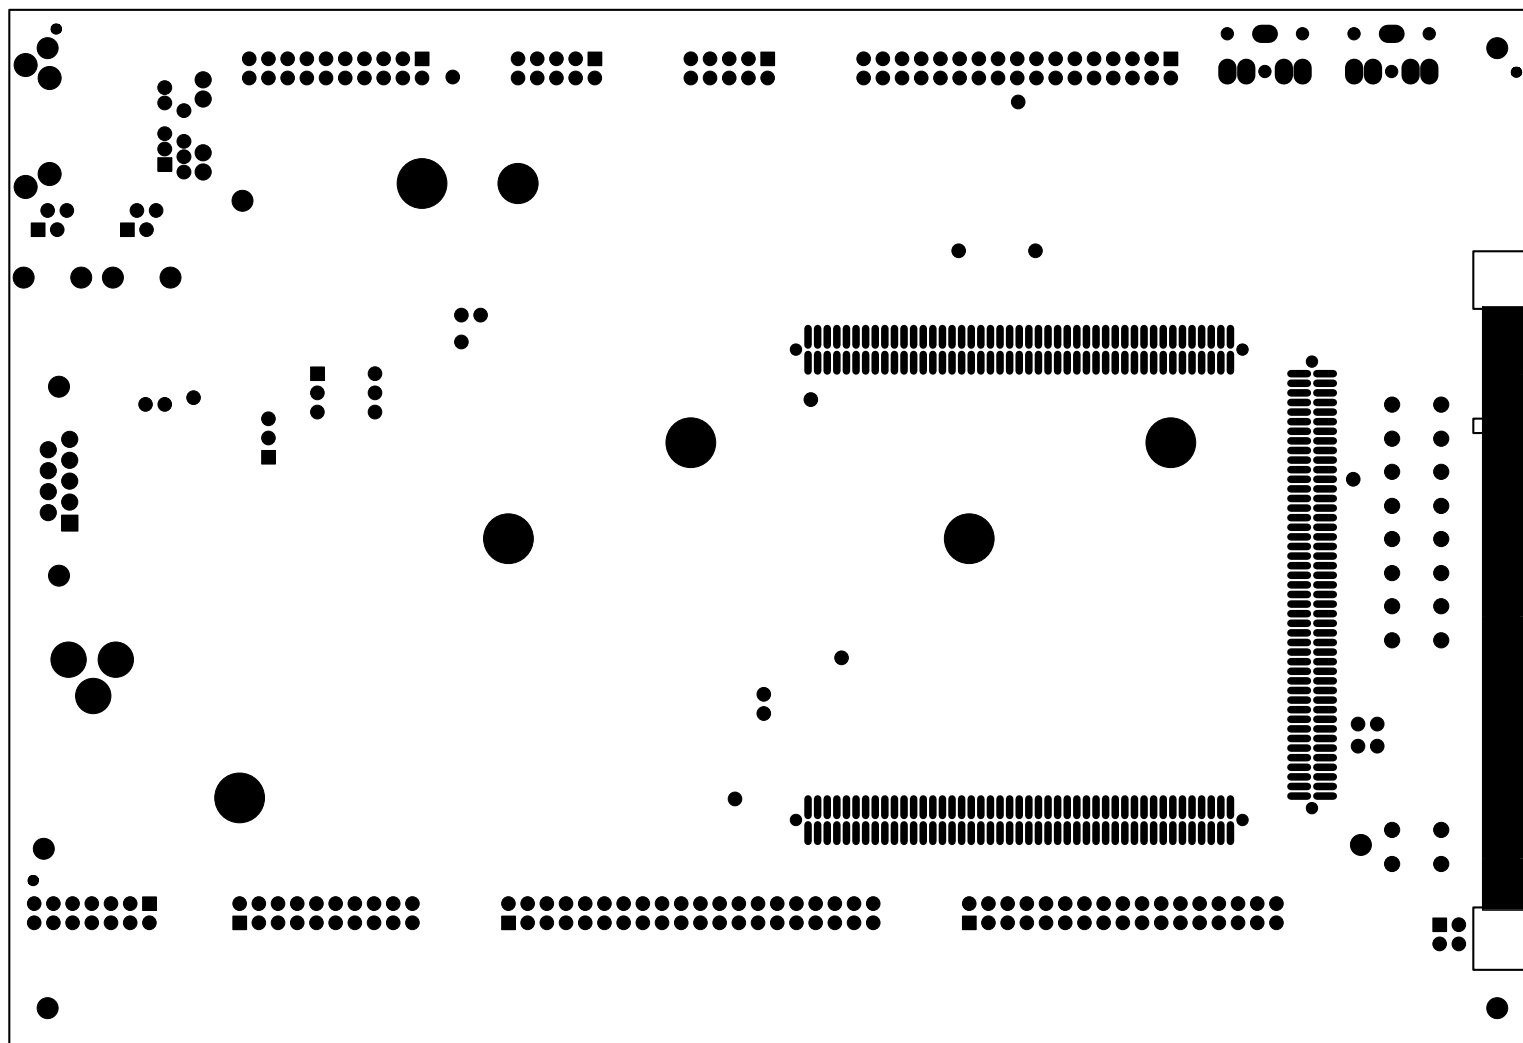


UNLESS OTHERWISE SPECIFIED DIMENSIONS ARE IN INCHES TOLERANCES ARE : .XX +/- .010 .XXX +/- .005	CONTRACT NO.		 20 Cotton Road Nashua, New Hampshire 03063 (603) 883-2430 FAX (603) 882-2655	
	APPROVALS	DATE		
MATERIAL	DRAWN	01/23/07	SOLDER MASK BOTTOM SIDE ADSP-BF537 EZ-KIT LITE	
	CHECKED			
FINISH	ENGINEERING		SIZE B	REV. 2.2
	QUALITY		DWG. NO. A0188-2004-REF	
DO NOT SCALE THIS DRAWING	MANUFACTURING		SCALE 1 : 1	SHEET 10 OF 14

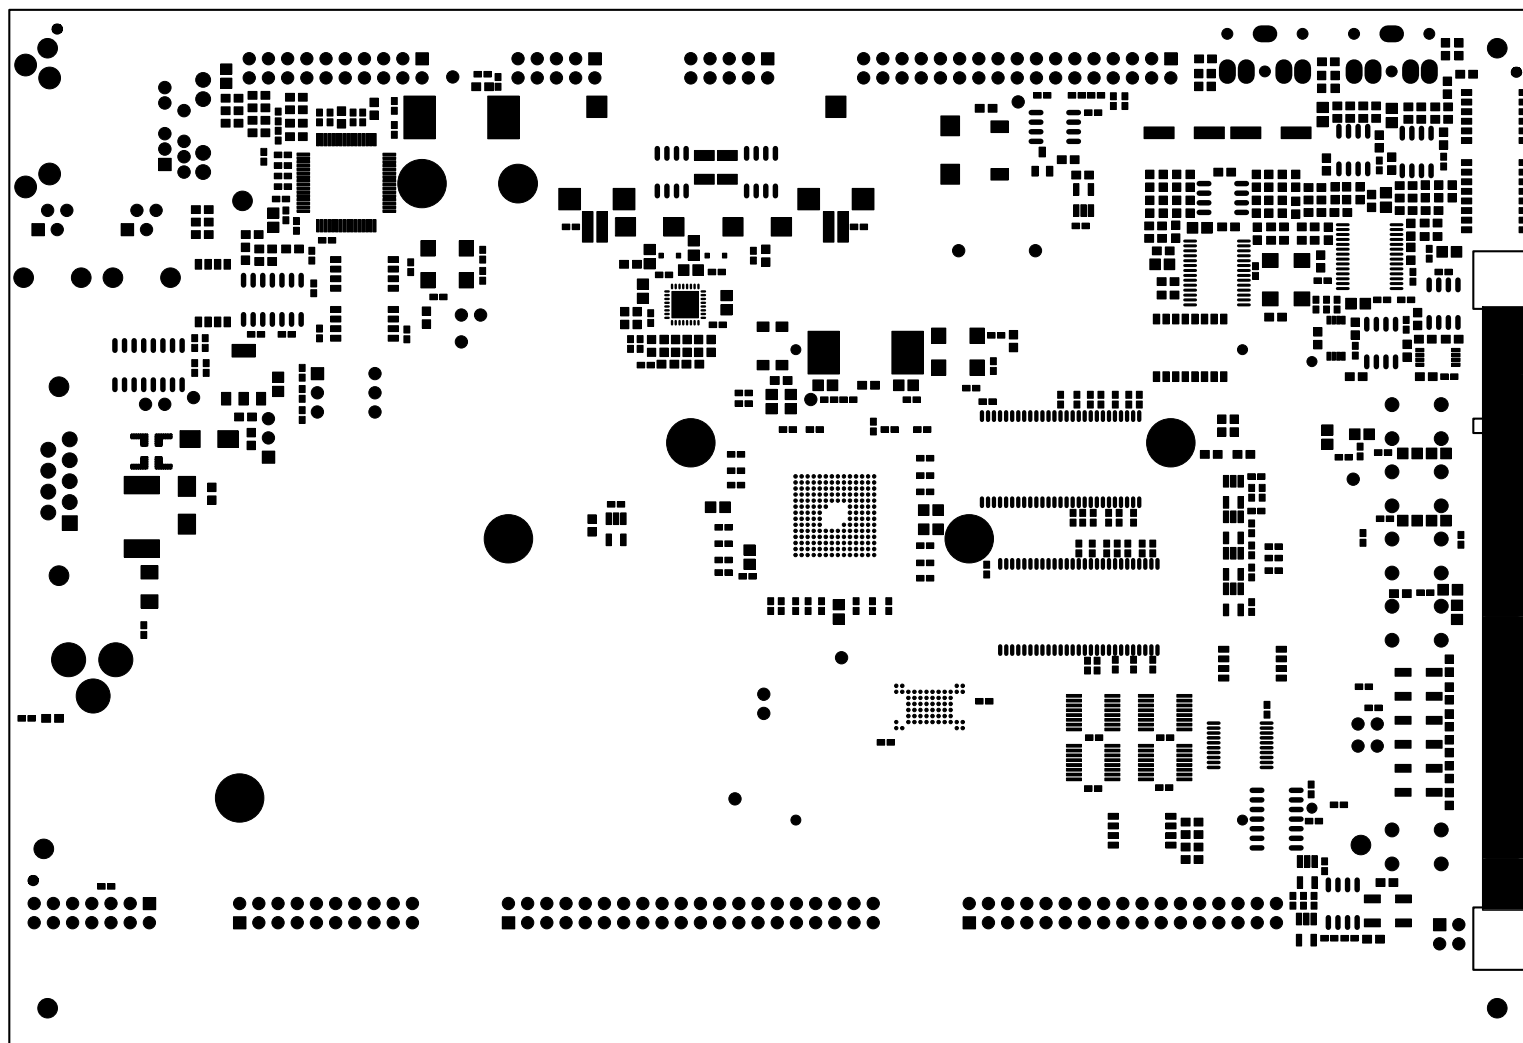

UNLESS OTHERWISE SPECIFIED DIMENSIONS ARE IN INCHES TOLERANCES ARE : .XX +/- .010 .XXX +/- .005	CONTRACT NO.		 20 Cotton Road Nashua, New Hampshire 03063 (603) 883-2430 FAX (603) 882-2655	
	APPROVALS	DATE		
MATERIAL	DRAWN	01/23/07	SOLDER MASK TOP SIDE ADSP-BF537 EZ-KIT LITE	
	CHECKED			
FINISH	ENGINEERING		SIZE	REV.
	QUALITY		B	2.2
DO NOT SCALE THIS DRAWING	MANUFACTURING		SCALE 1 : 1	SHEET 9 OF 14
			DWG. NO.	A0188-2004-REF

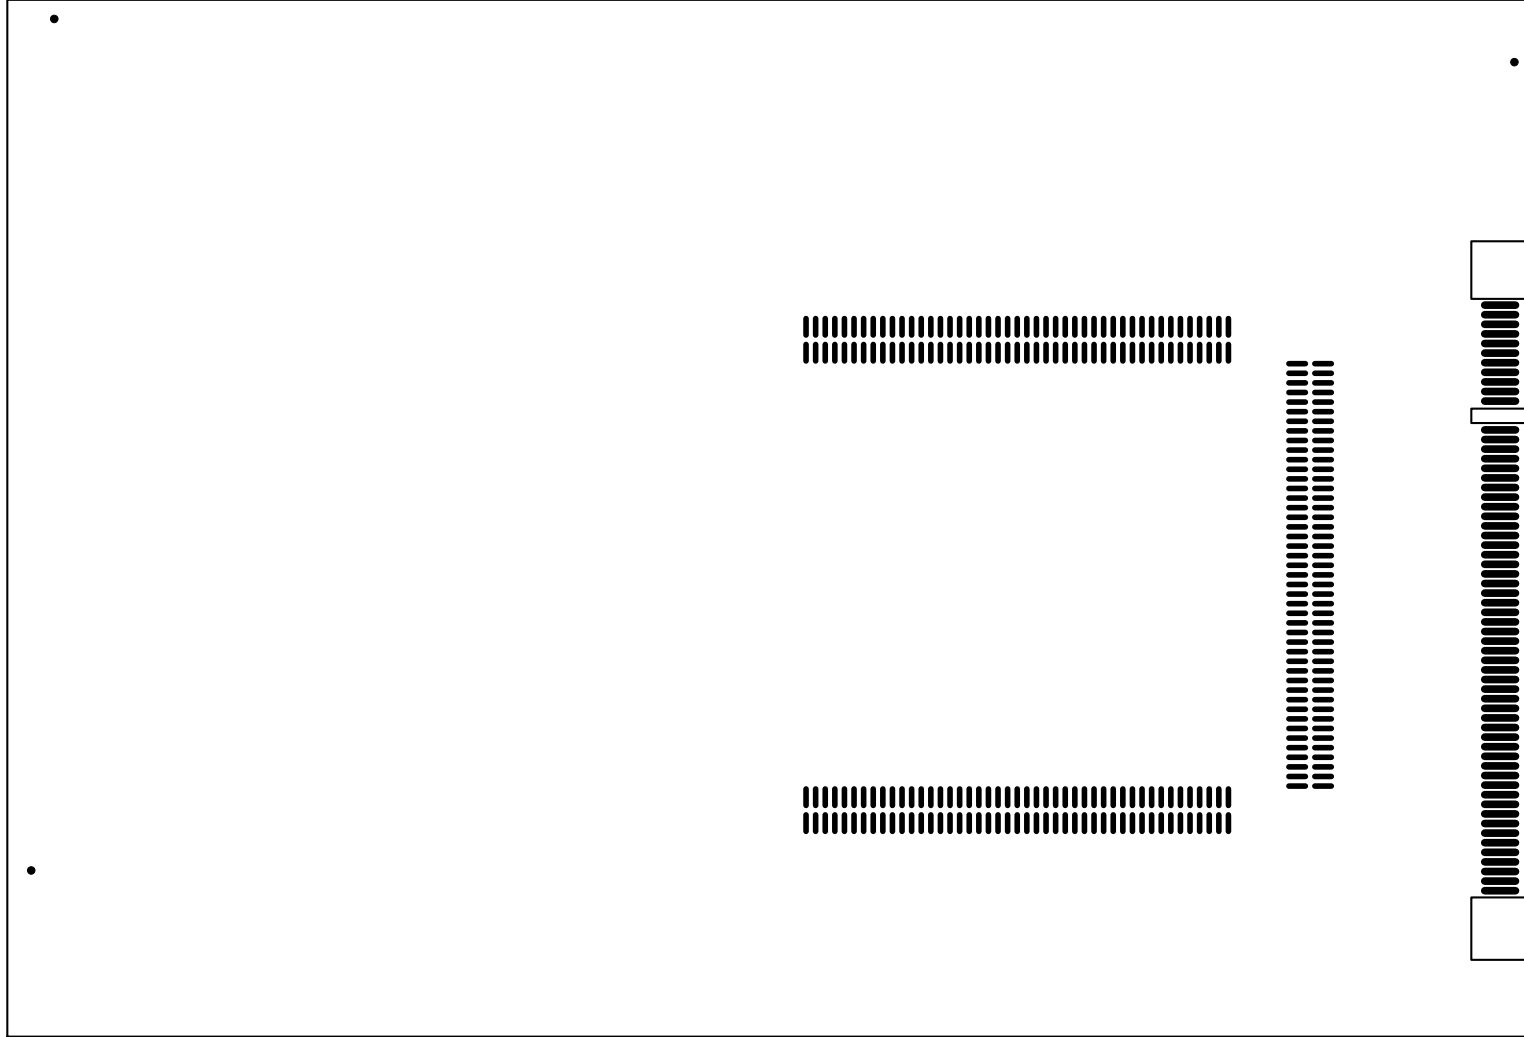

UNLESS OTHERWISE SPECIFIED DIMENSIONS ARE IN INCHES TOLERANCES ARE : .XX +/- .010 .XXX +/- .005	CONTRACT NO.		 20 Cotton Road Nashua, New Hampshire 03063 (603) 883-2430 FAX (603) 882-2655		
	APPROVALS	DATE			
MATERIAL	DRAWN	01/23/07	SOLDER PASTE BOTTOM SIDE ADSP-BF537 EZ-KIT LITE		
	CHECKED				
FINISH	ENGINEERING		SIZE	DWG. NO. A0188-2004-REF	REV. 2.2
	QUALITY		B		
DO NOT SCALE THIS DRAWING	MANUFACTURING		SCALE 1 : 1	SHEET 14 OF 14	

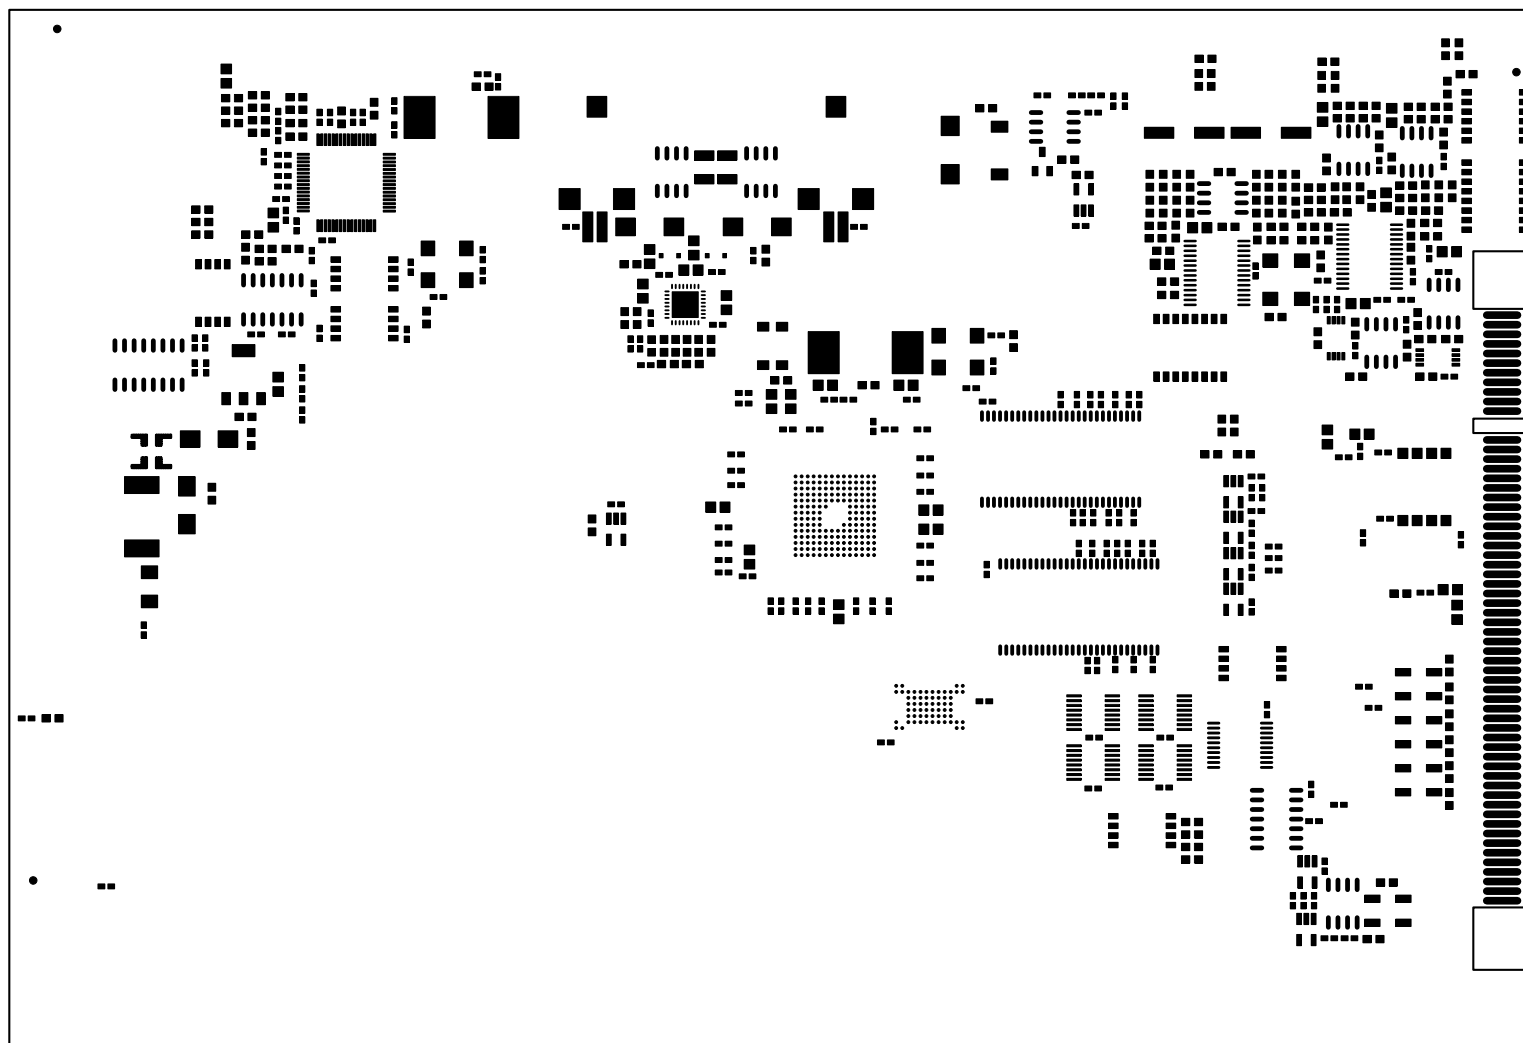

UNLESS OTHERWISE SPECIFIED DIMENSIONS ARE IN INCHES TOLERANCES ARE : .XX +/- .010 .XXX +/- .005	CONTRACT NO.		 20 Cotton Road Nashua, New Hampshire 03063 (603) 883-2430 FAX (603) 882-2655	
	APPROVALS	DATE		
MATERIAL	DRAWN	01/23/07	SOLDER PASTE TOP SIDE ADSP-BF537 EZ-KIT LITE	
	CHECKED			
FINISH	ENGINEERING		SIZE B	REV. 2.2
	QUALITY		DWG. NO. A0188-2004-REF	
DO NOT SCALE THIS DRAWING	MANUFACTURING		SCALE 1 : 1	SHEET 13 OF 14