
 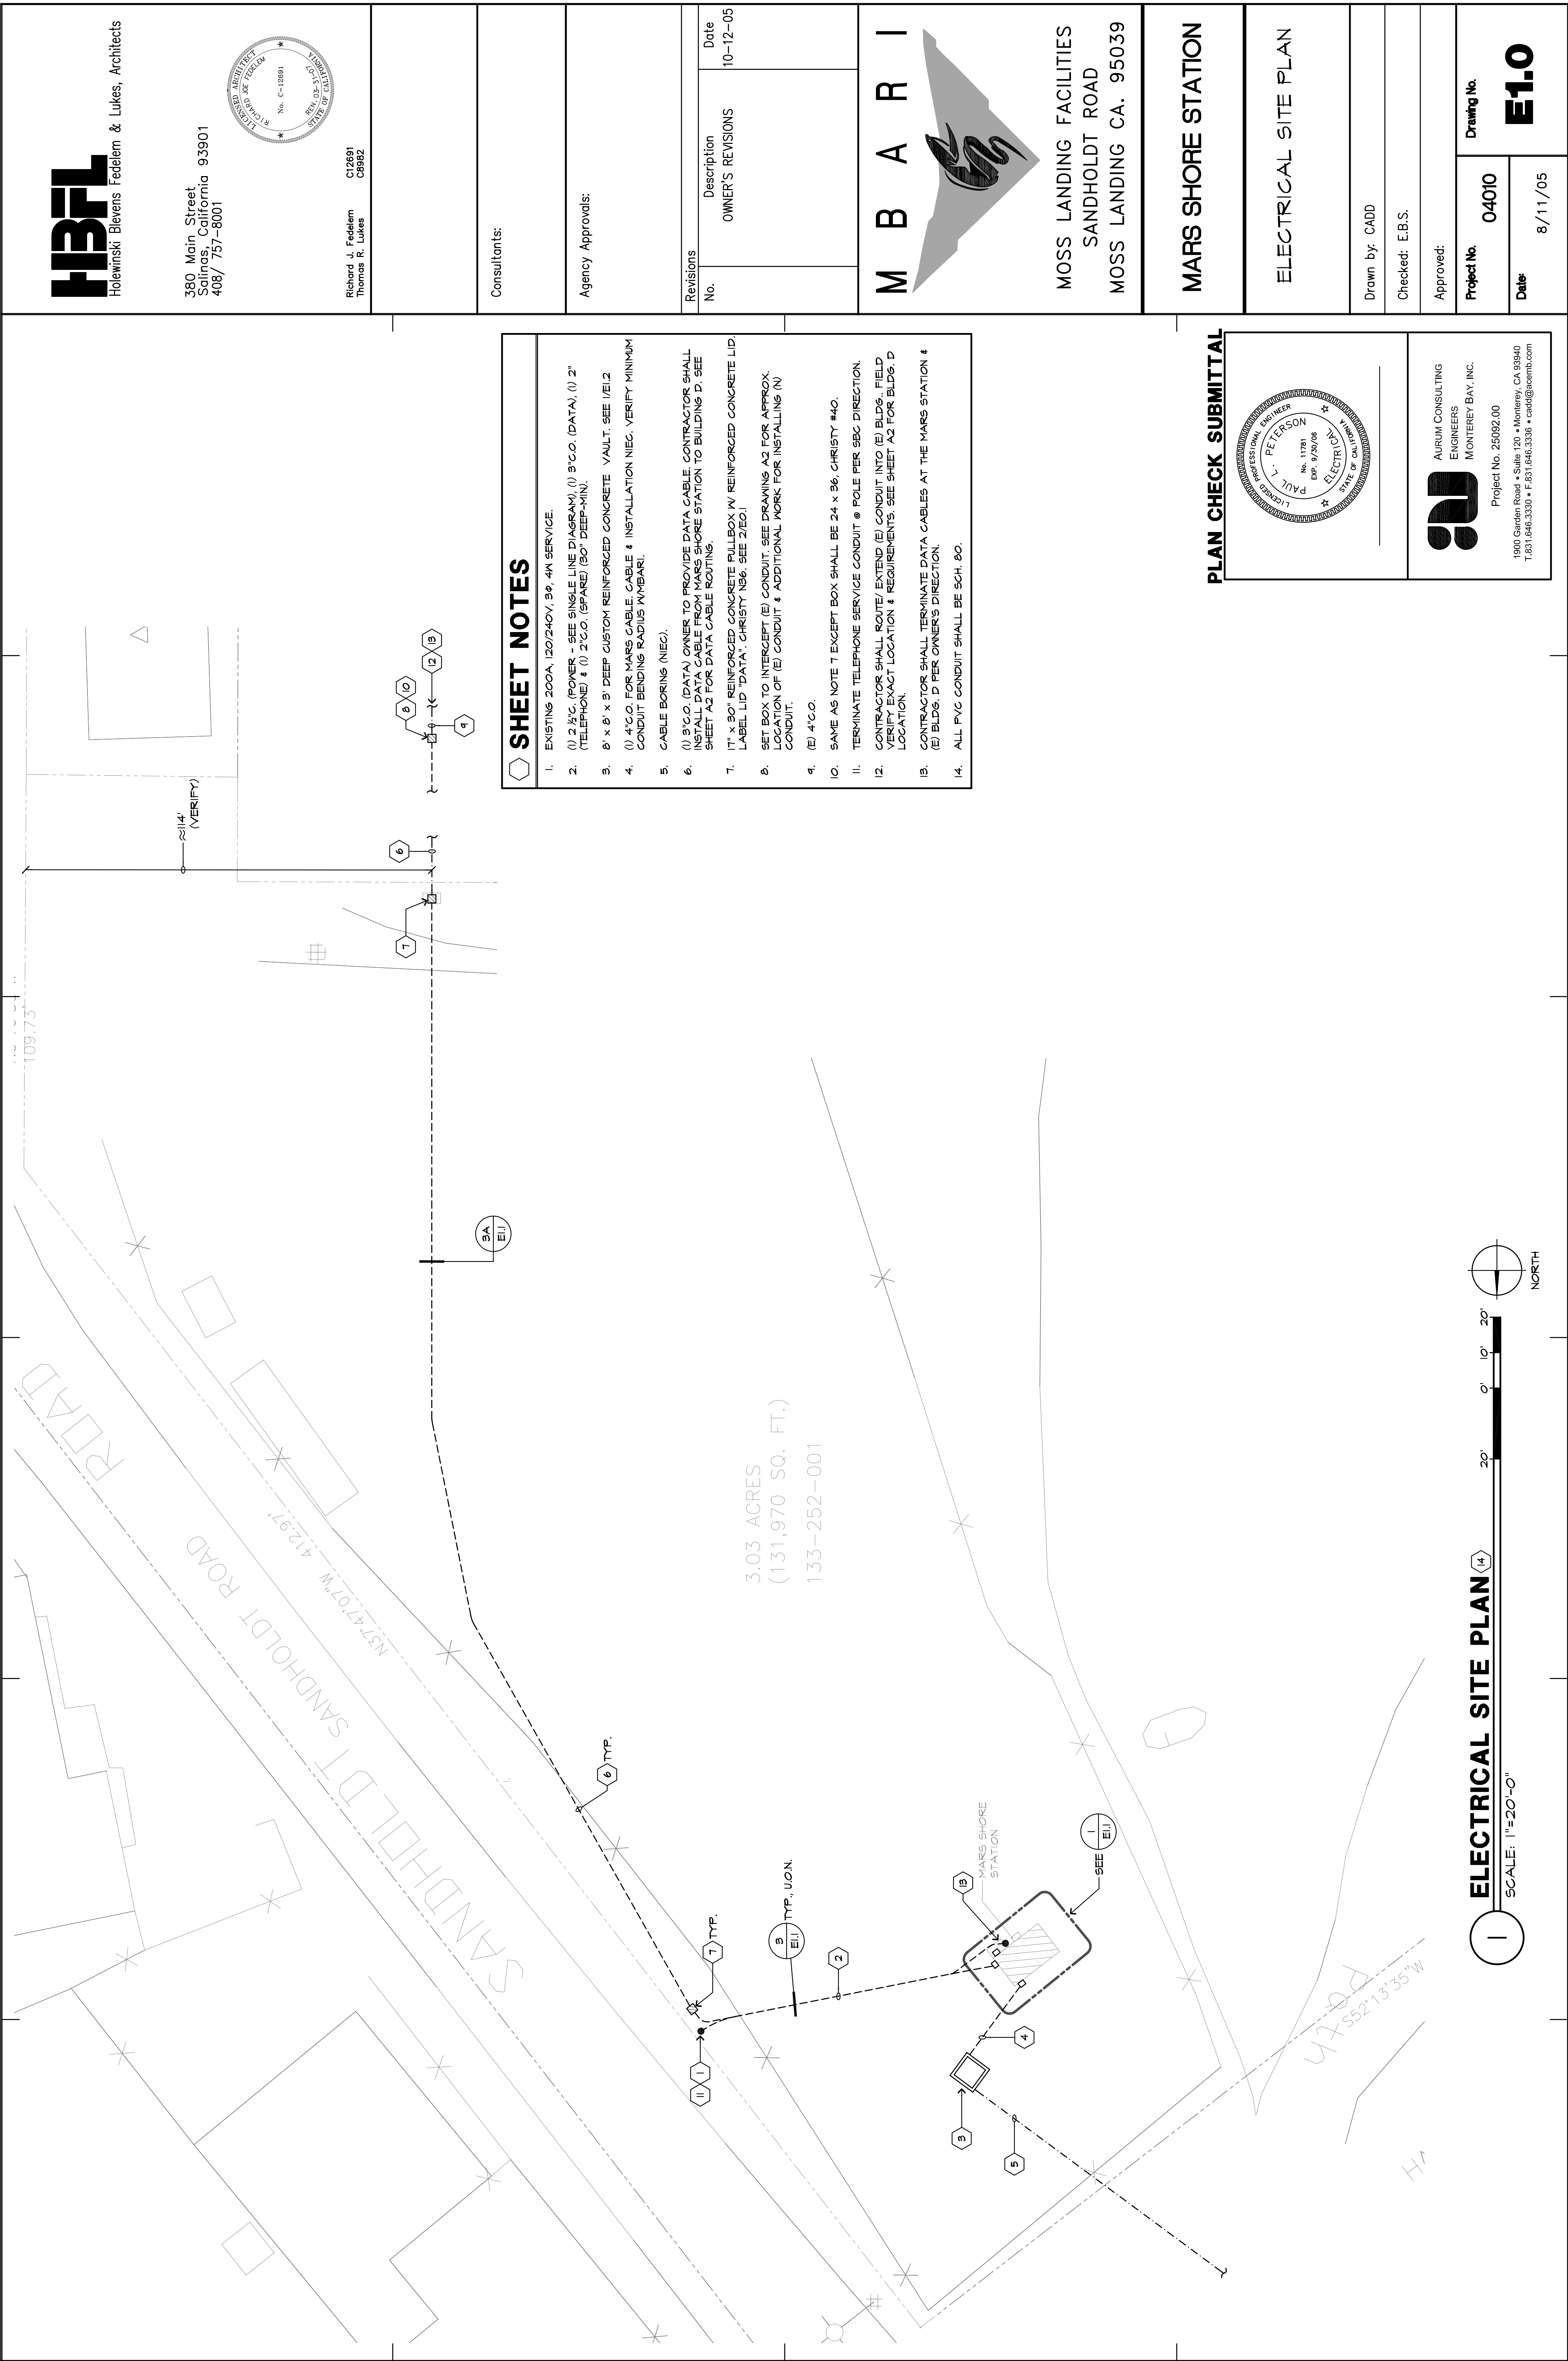
 
 
 
 
 


IF THIS SHEET IS NOT 24" X 36", IT IS A
REDUCED PRINT. SCALE ACCORDINGLY




SHEET NOTES

- EXISTING 200A, 120/240V, 3Ø, 4N SERVICE.
- (1) 2"VC (POWER - SEE SINGLE LINE DIAGRAM), (1) 3"CO (DATA), (1) 2" (TELEPHONE) & (1) 2"CO (SPARE) (60" DEEP-MIN).
- Ø' x Ø' x 3' DEEP CUSTOM REINFORCED CONCRETE VAULT. SEE /E/1.2
- (1) 4"CO FOR MARS CABLE. CABLE & INSTALLATION NEC. VERIFY MINIMUM CONDUIT BENDING RADIUS W/MBARI.
- CABLE BORING (NEC).
- (1) 3"CO (DATA) OWNER TO PROVIDE DATA CABLE. CONTRACTOR SHALL INSTALL DATA CABLE FROM MARS SHORE STATION TO BUILDING D. SEE SHEET A2 FOR DATA CABLE ROUTING.
- 11" x 30" REINFORCED CONCRETE BULLBOX W/ REINFORCED CONCRETE LID. LABEL LID "DATA". CHRISTY NSG. SEE 2/EO.
- SET BOX TO INTERCEPT (E) CONDUIT. SEE DRAWING A2 FOR APPROX. LOCATION OF (E) CONDUIT & ADDITIONAL WORK FOR INSTALLING (N) CONDUIT.
- (E) 4"CO.
- SAME AS NOTE T EXCEPT BOX SHALL BE 24 x 36, CHRISTY #40.
- TERMINATE TELEPHONE SERVICE CONDUIT @ POLE PER SEC DIRECTION.
- CONTRACTOR SHALL ROUTE/ EXTEND (E) CONDUIT INTO (E) BLDG. FIELD IDENTIFY EXACT LOCATION & REQUIREMENTS. SEE SHEET A2 FOR BLDG. D LOCATION.
- CONTRACTOR SHALL TERMINATE DATA CABLES AT THE MARS STATION & (E) BLDG. D PER OWNER'S DIRECTION.
- ALL PVC CONDUIT SHALL BE SCH. 80.

PLAN CHECK SUBMITTAL

AURUM CONSULTING
ENGINEERS
MONTEREY BAY, INC.
Project No. 25092.00
1900 Garden Road • Suite 120 • Monterey, CA 93940
1.251.046.3330 • F.251.046.3330 • cad@aurum.com

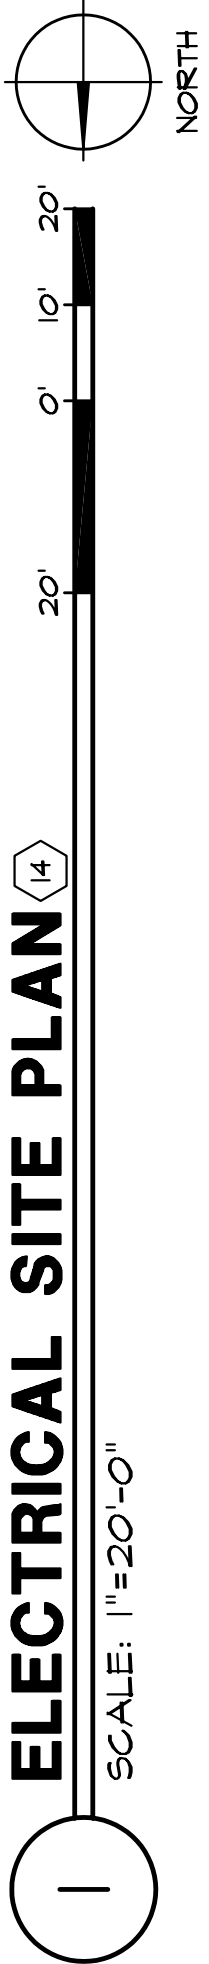


ELECTRICAL SITE PLAN (14)

SCALE: 1"=20'-0"

HBF

Holewinski Blevens Fedelem & Lukes, Architects

380 Main Street
Salinas, California 93901
408/ 757-8001

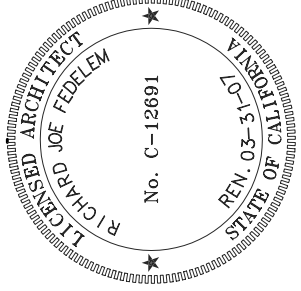

Richard J. Fedelem
Thomas R. Lukes
C12691
C5862

Consultants:

Agency Approvals:

Revisions

No.

Description

OWNER'S REVISIONS

Date

10-12-05

M B A R I



MOSS LANDING FACILITIES
SANDHOLDT ROAD
MOSS LANDING CA. 95039

MARS SHORE STATION

ELECTRICAL SITE PLAN

Drawn by: CADD

Checked: E.B.S.

Approved:

Project No. 04010

Drawing No.

Date

8/11/05

E1.0