



Diagram illustrating the installation of a 16" diameter manhole. The diagram shows a cross-section of the manhole structure, including the concrete manhole body, the sand bedding, and the native material surrounding the structure. Key dimensions and materials are labeled:


- 16"**: Diameter of the manhole.
- 3" MIN.**: Minimum thickness of the sand bedding.
- 3" MIN.**: Minimum thickness of the native material surrounding the manhole.
- 3" MIN.**: Minimum thickness of the concrete manhole body.
- SAND BEDDING**: The layer of sand directly beneath the manhole.
- CONDUIT SEE PLANS FOR QUANTITY, SIZE AND USAGE**: The conduit passing through the manhole.
- NATIVE MATERIAL AT 95% COMPACTION**: The surrounding soil material.
- FINISHED GRADE**: The ground level above the manhole.

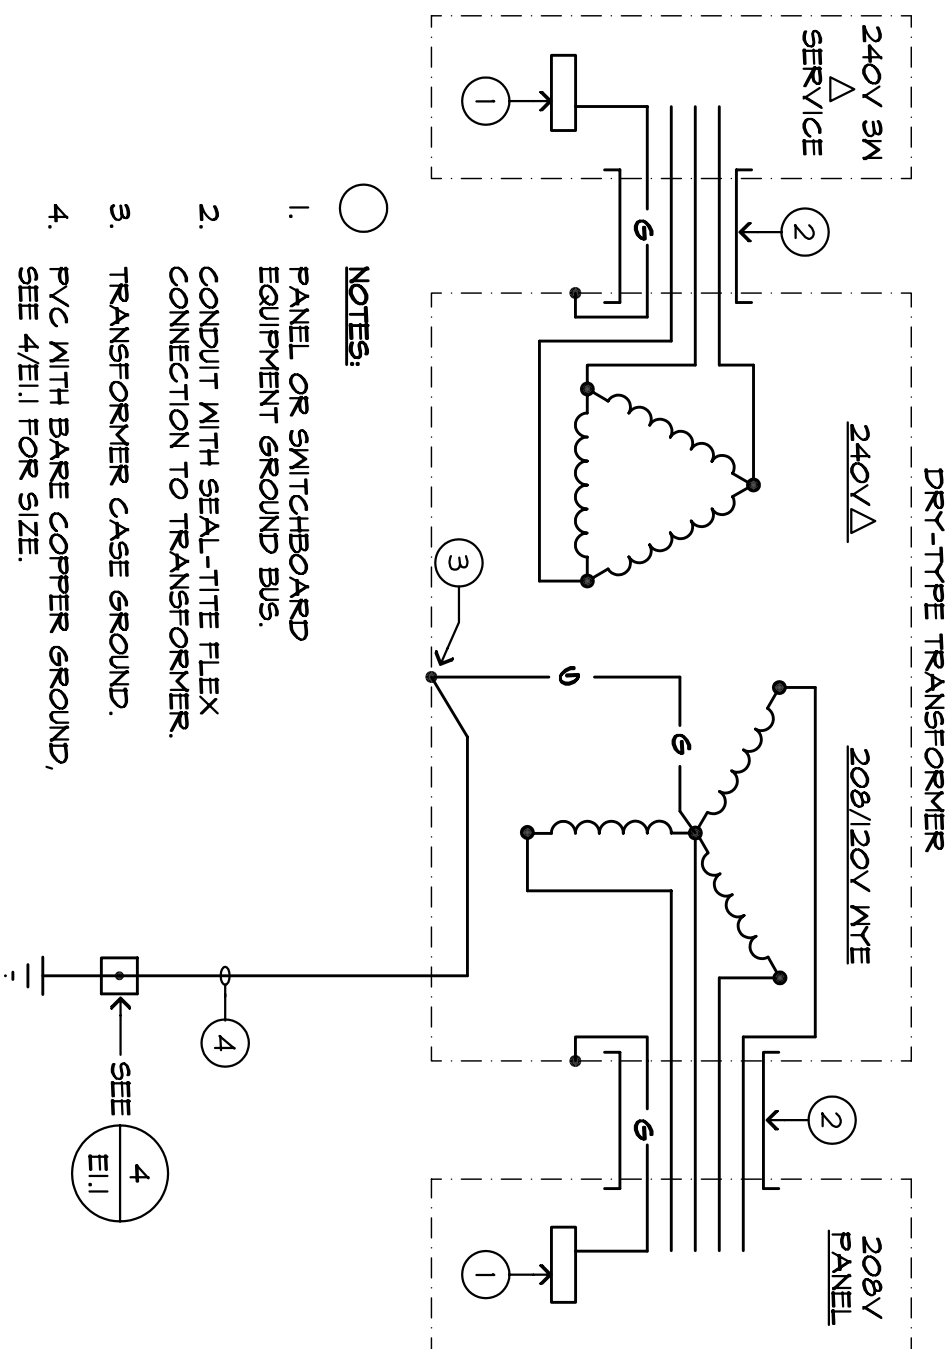


NO SCALE

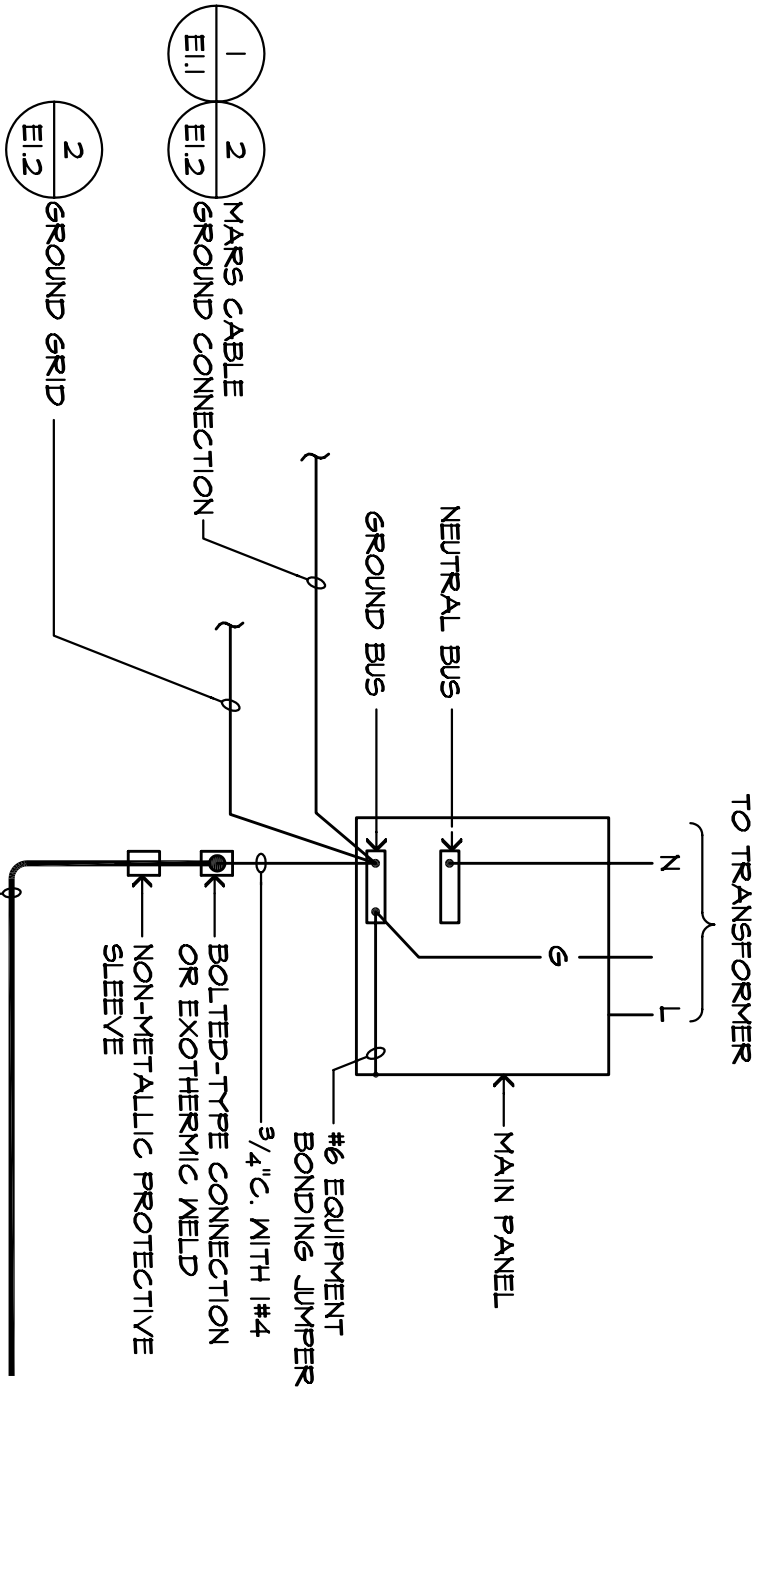


NO SCALE

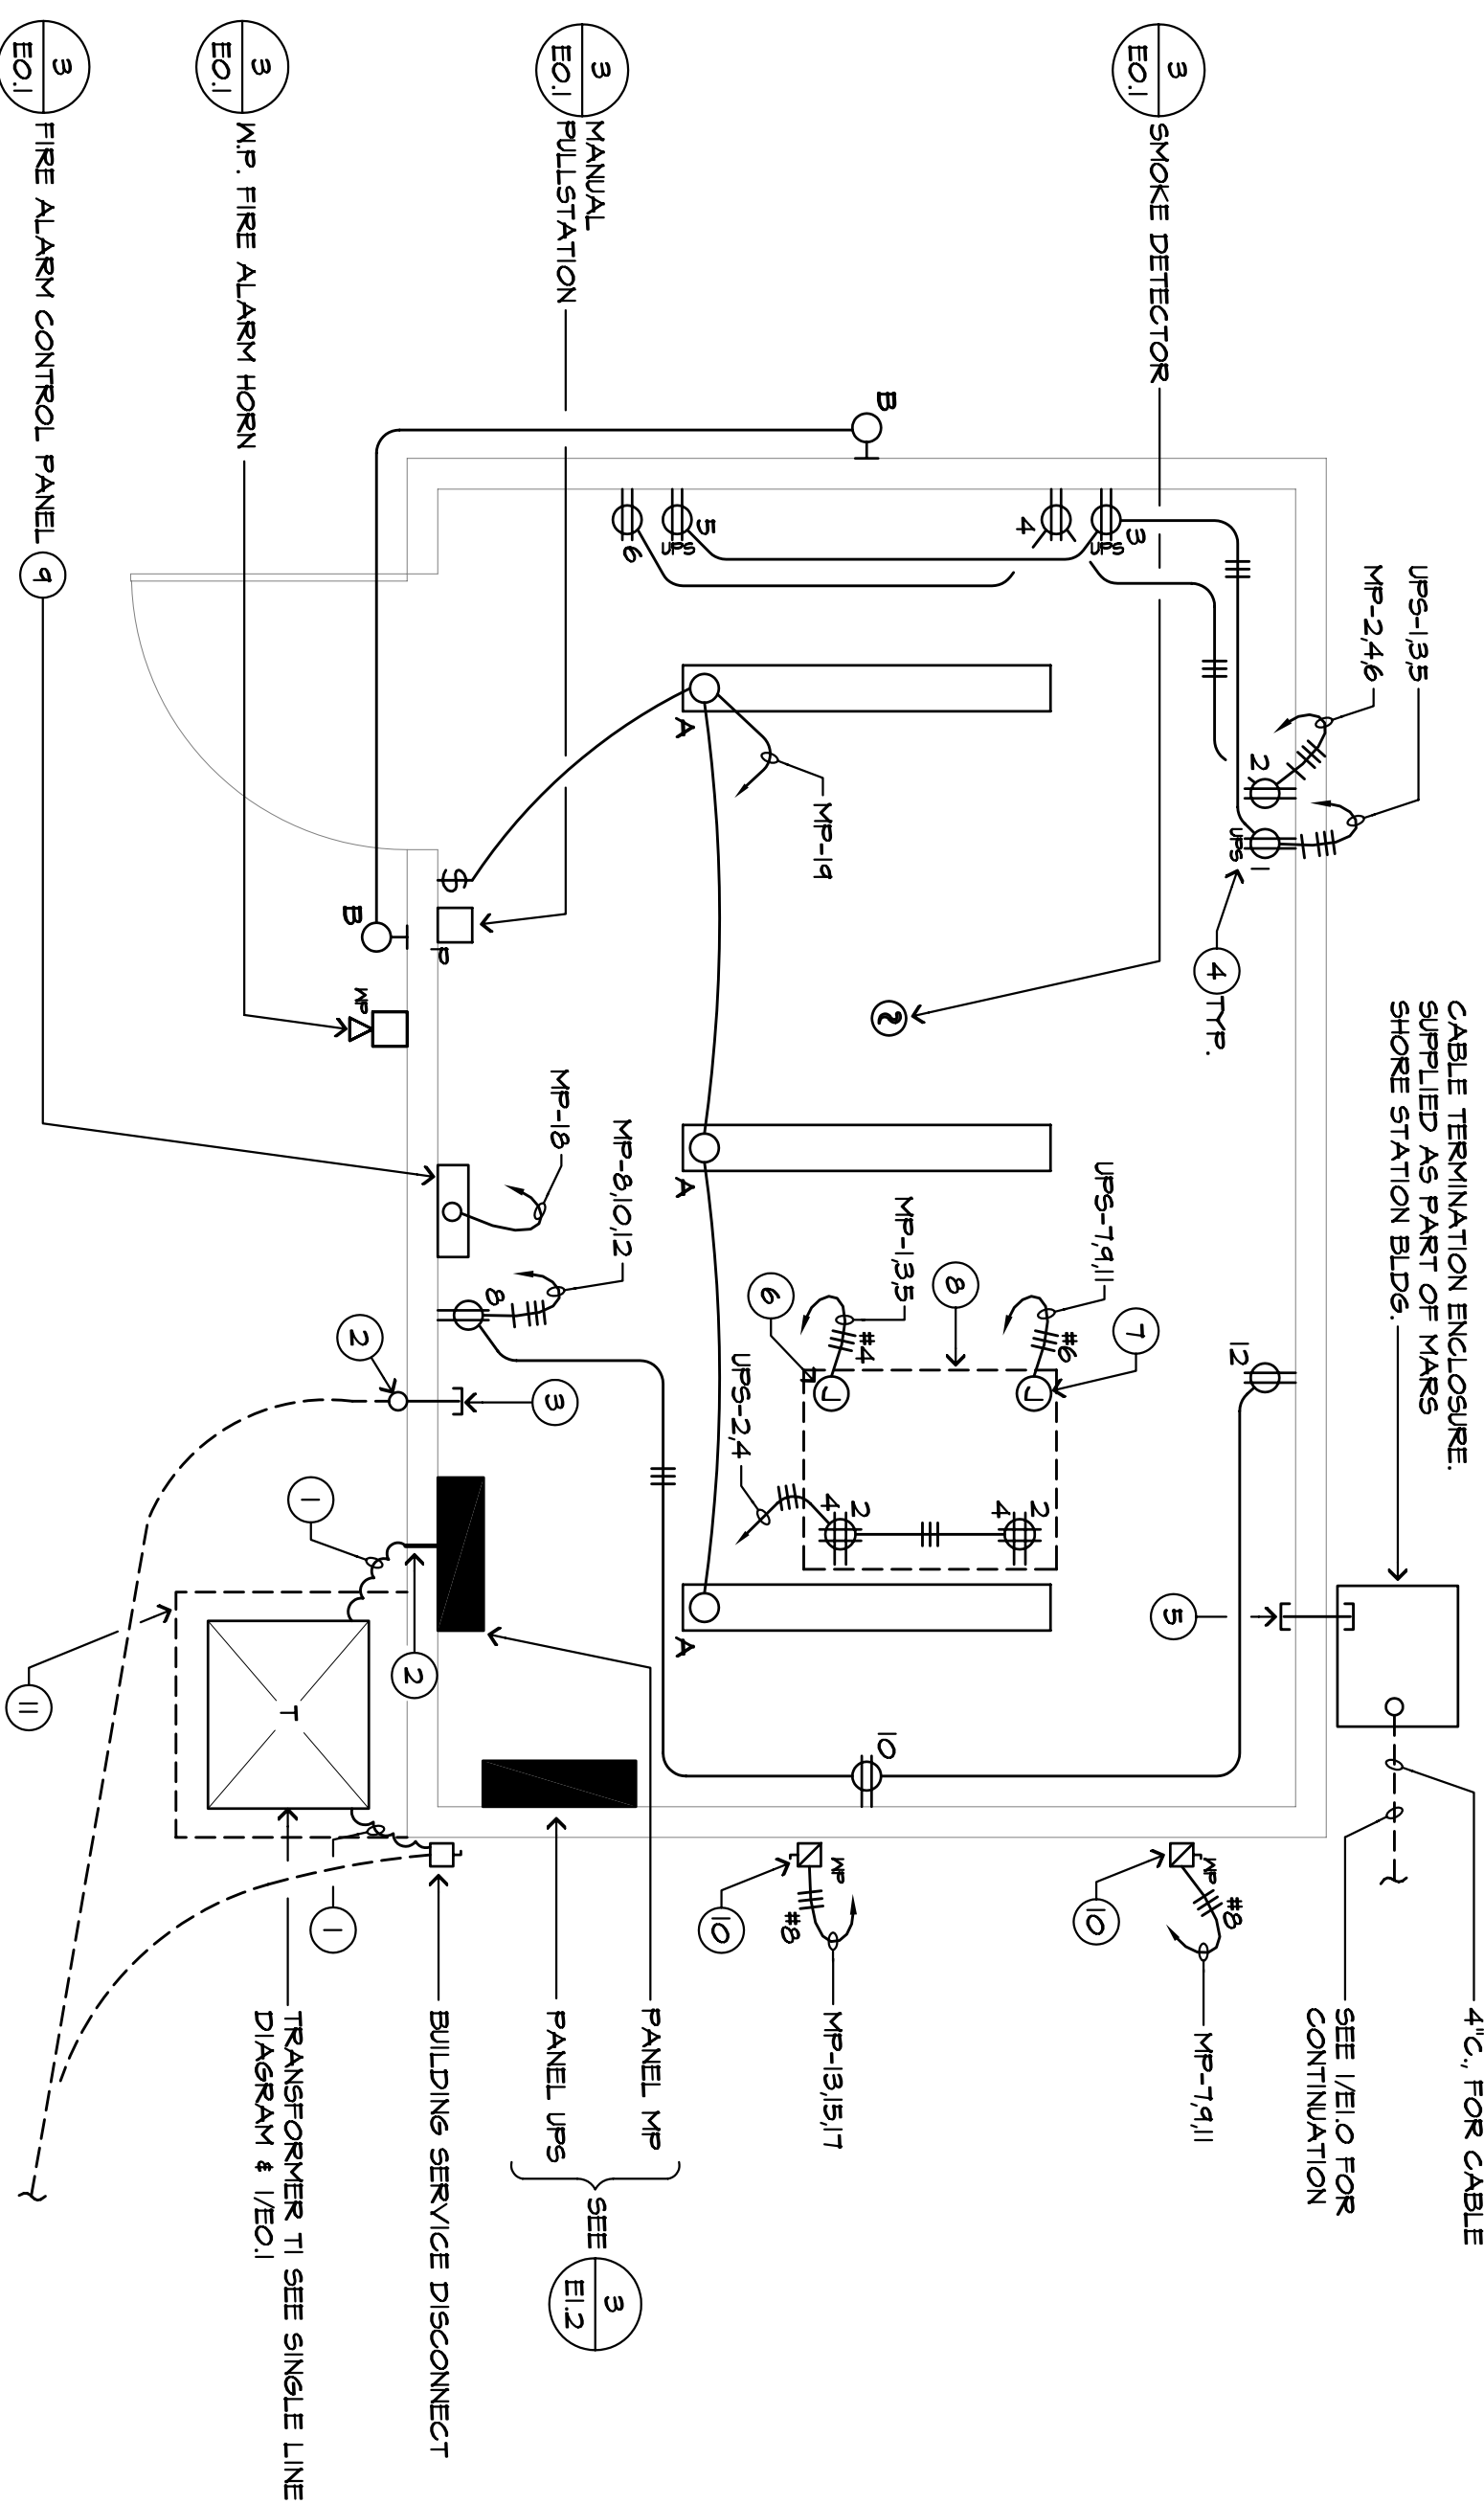

SCALE: 1/2"=1'-0"

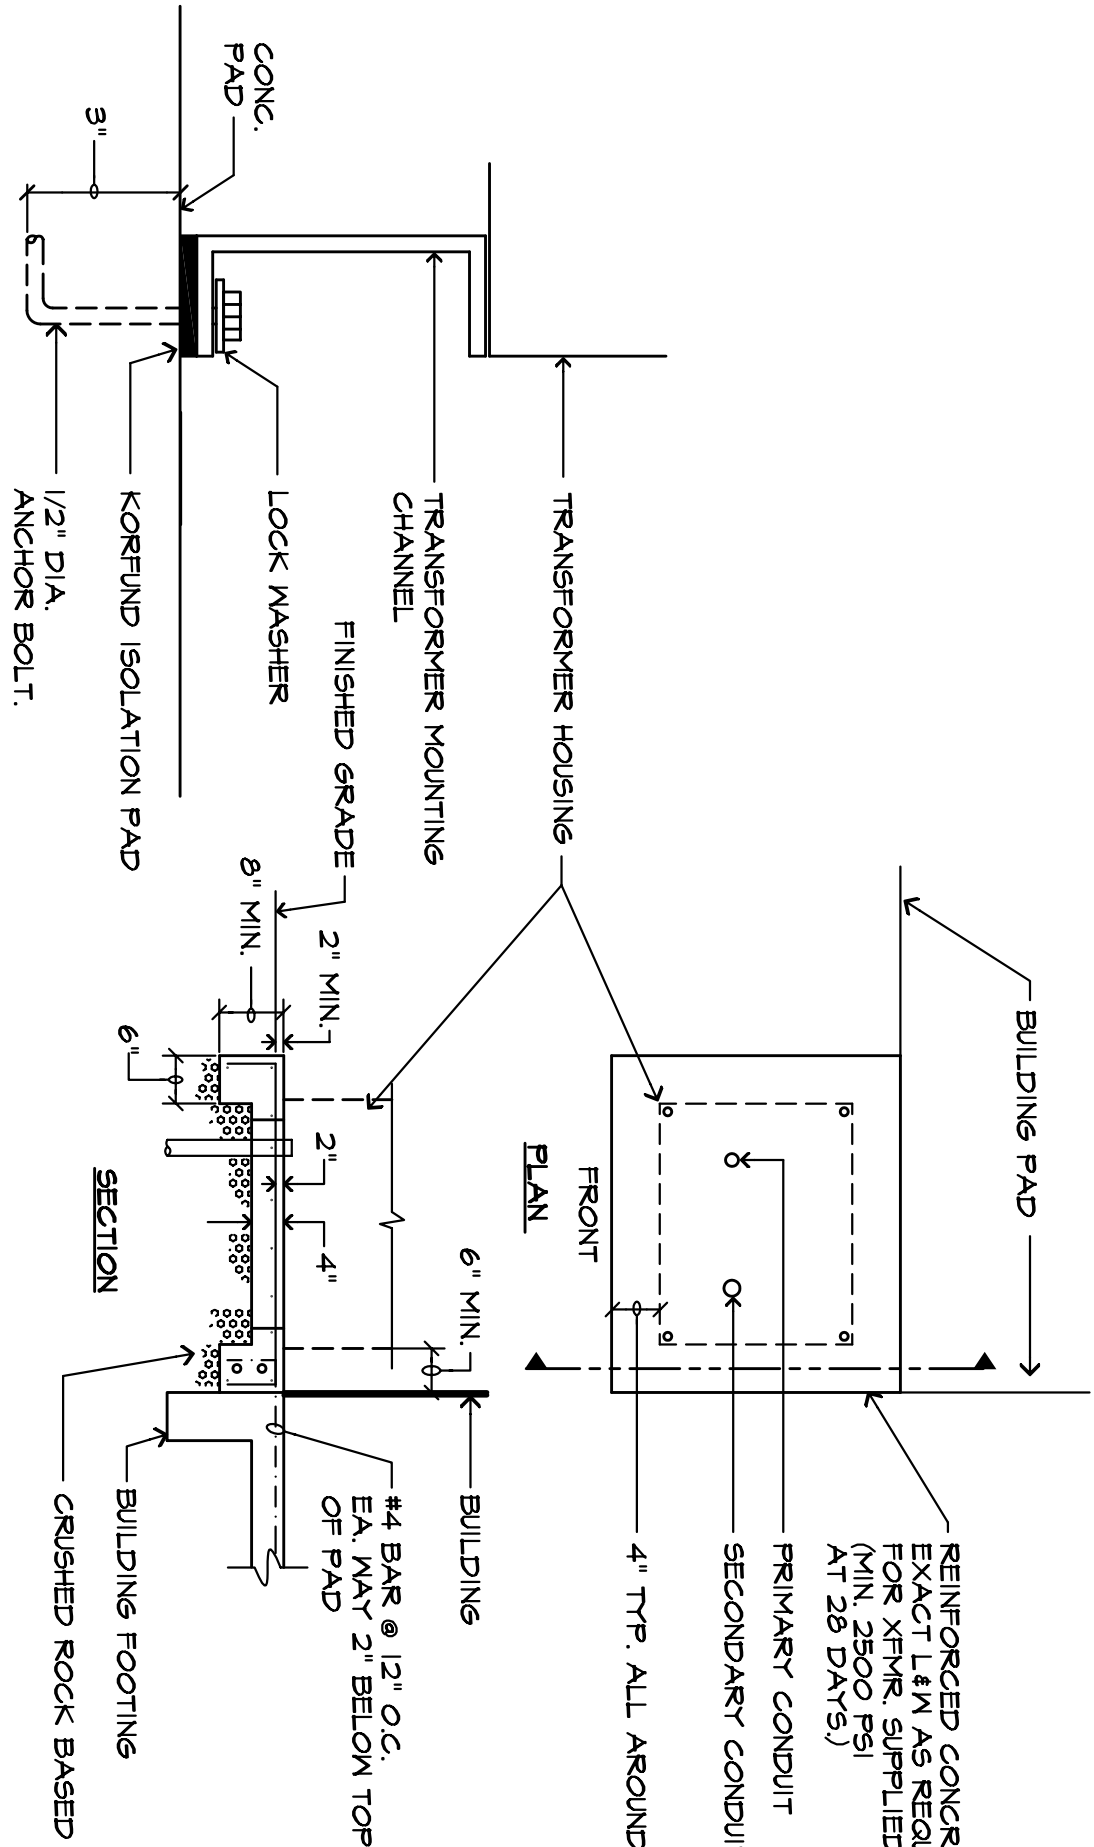

NO SCALE

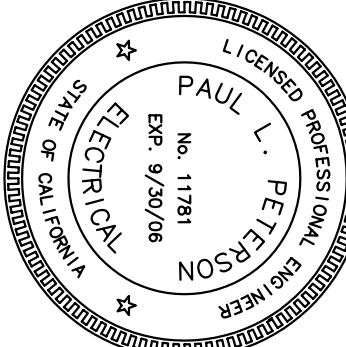

PLAN CHECK SUBMITTAL



Project No. 25092.00

1900 Garden Road • Suite 120 • Monterey, CA 93940
T. 831.646.3330 • F. 831.646.3336 • cadd@acemb.com

6.

Date: _____

ELECTRICAL FLOOR PLAN,
\$ DETAILS


MARS SHORE STATION

MOSS LANDING FACILITIES
SANDHOLDT ROAD
MOSS LANDING CA. 95039

MOSS LANDING CA. 95039

Fedelem & Lukes, Architects

80 Main Street
Salinas, California 93901
408 / 757-8001

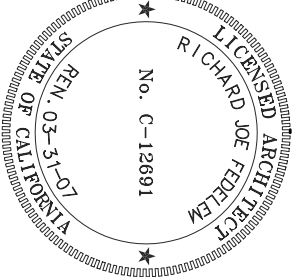

Richard J. Fedelem C1269
Thomas R. Lukes C8982

Thomas R. Lukes C8982

Thomas R. Lukes C8982

Consultants:

Agency Approval/s:

Revisions No.	Description	Date
	OWNER'S REVISIONS	10-12-05

MBARI

