 


PANELBOARD SCHEDULE



-

NOTE: CORNER OF BOX NOT SHOWN FOR CLARITY


CABLE VAULT

NO SCALE

PANEL UPS


KVA Phase A	.
KVA Phase B	.
KVA Phase C	.

Total Load KVA	.
Total Load Amperes	.

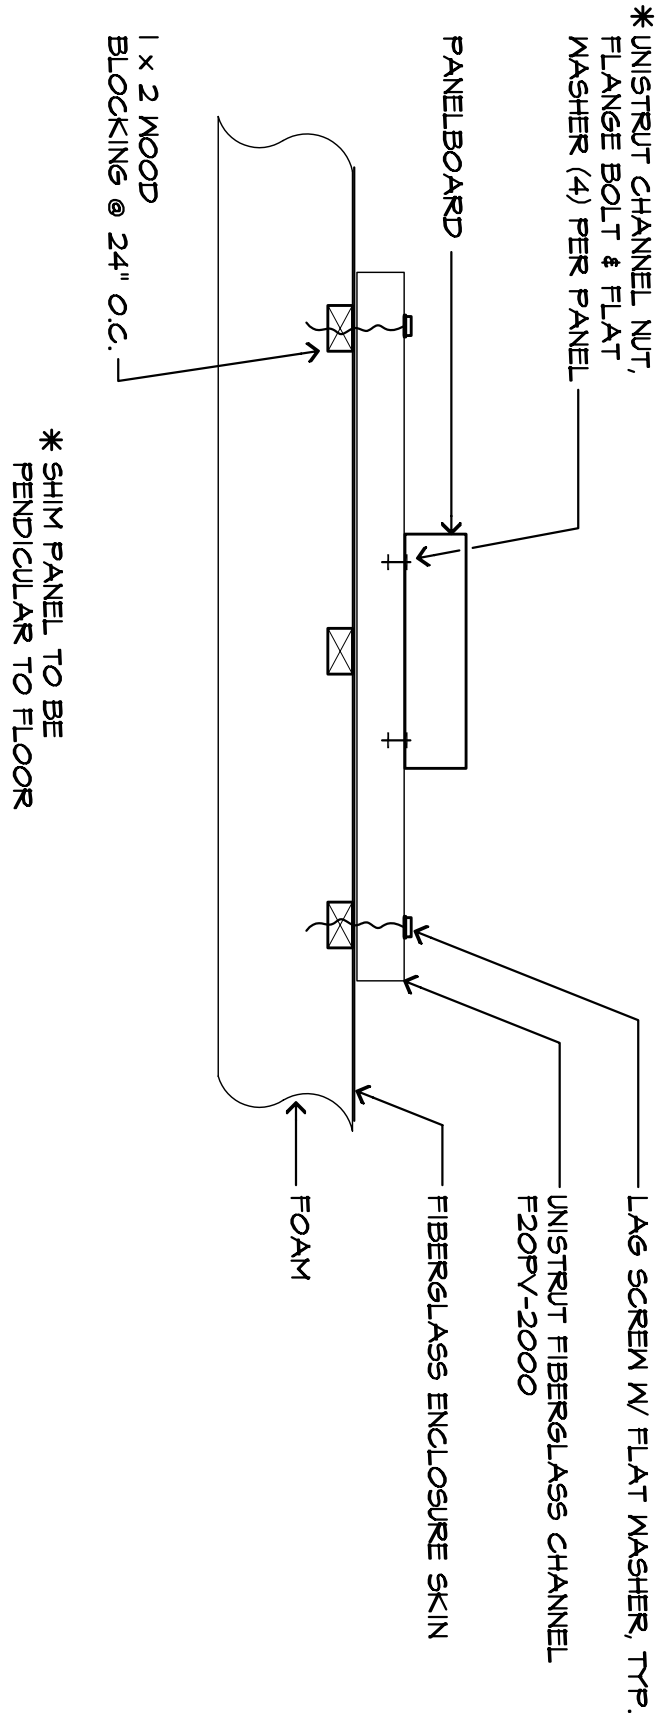

PANELBOARD / EQUIPMENT MOUNTING

NO SCALE

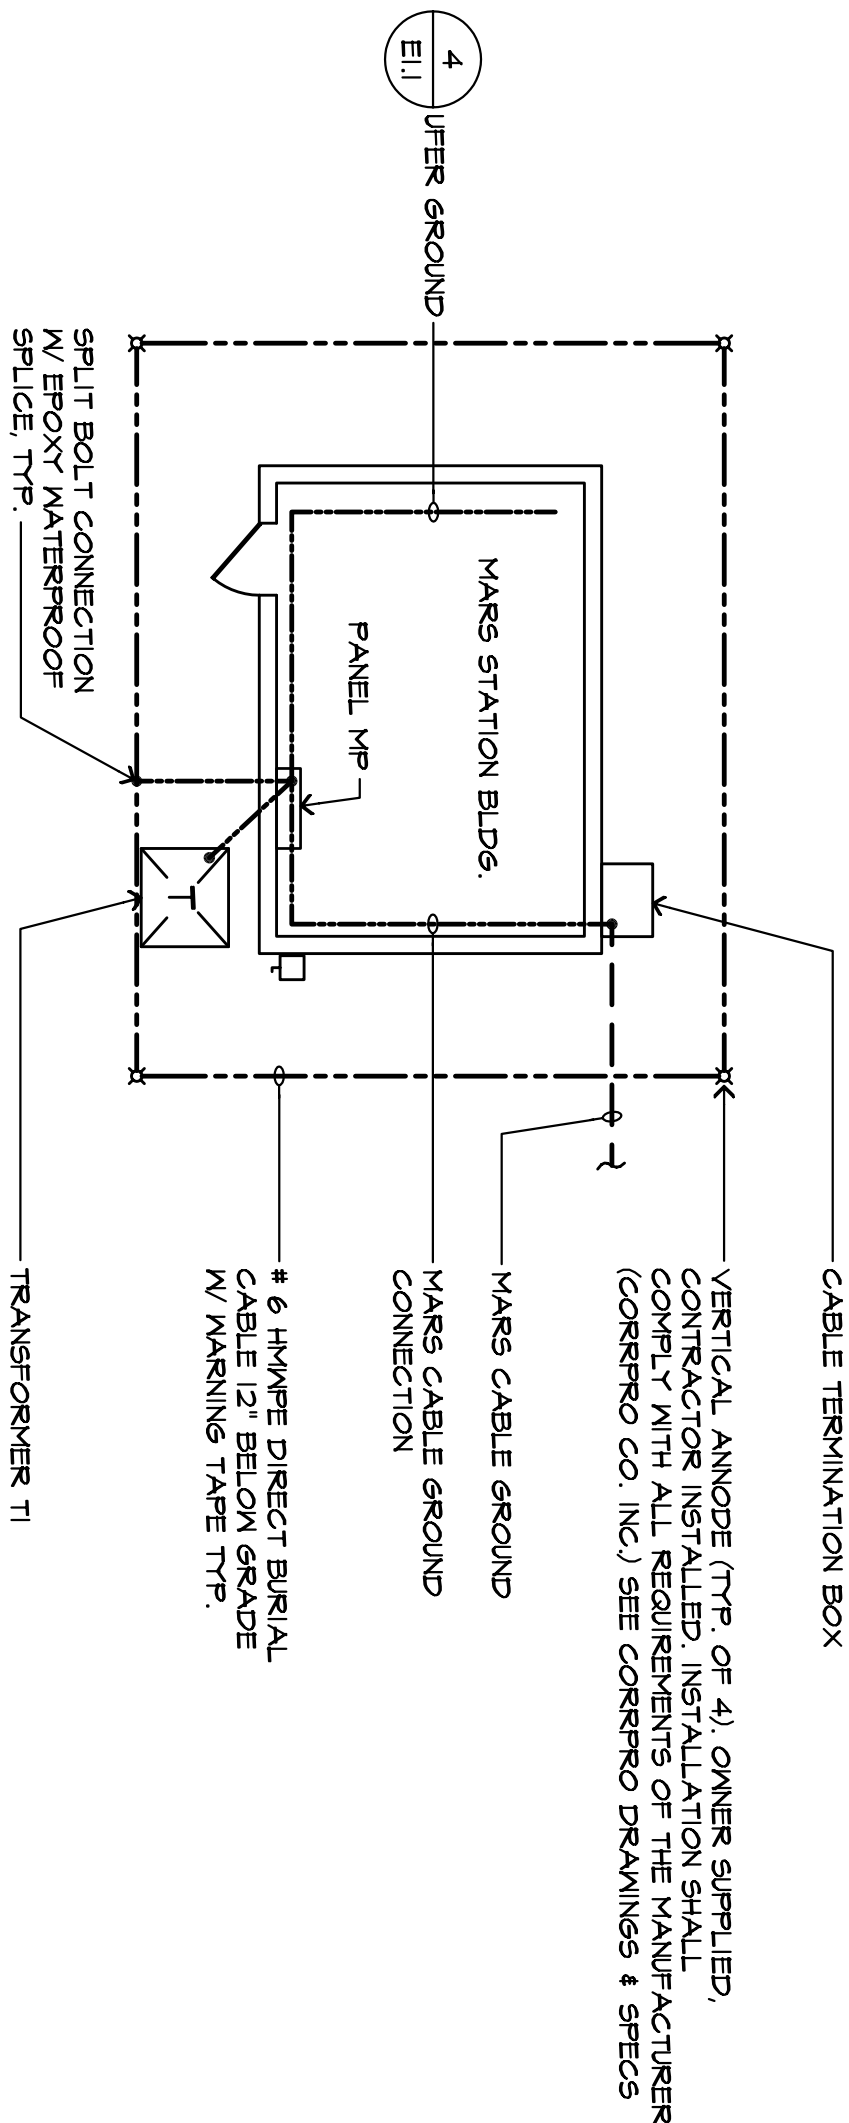

BUILDING GROUNDING

NO SCALE


PANEL MP

KVA Phase A	14.5
KVA Phase B	14.0
KVA Phase C	14.0

Total Load KVA	42.5
Total Load Amperes	119

① PROVIDE LOCK-ON DEVICE

Holewinski Blevens Feddem & Lukes, Architects
380 Main Street
Solinas, California 93901
408/ 757-8001

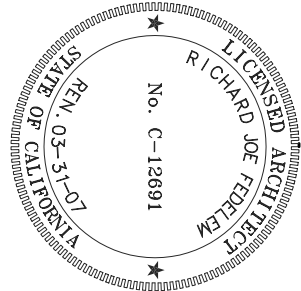

Richard J. Fedelem	C12697
Thomas R. Lukes	C8982

Consultants:

Agency Approvals:

Revisions		Date
No.	Description	
	OWNER'S REVISIONS	10-12-05


MBA R I



MOSS LANDING FACILITIES
SANDHOLDT ROAD
MOSS LANDING CA. 95039

MARS SHORE STATION

PLAN CHECK SUBMITTAL

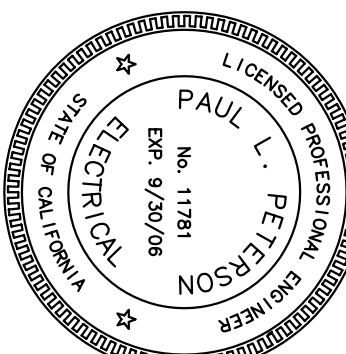

ELECTRICAL DETAILS, PANELBOARD SCHEDULES

Drawn by: CADD

Checked: E.B.S.



**AURUM CONSULTING
ENGINEERS**
MONTEREY BAY, INC.

Project No. 25092.00

1900 Garden Road • Suite 120 • Monterey, CA 93940
T.831.646.3330 • F.831.646.3336 • cadd@acemb.com

Date: 8/11/05

מד